
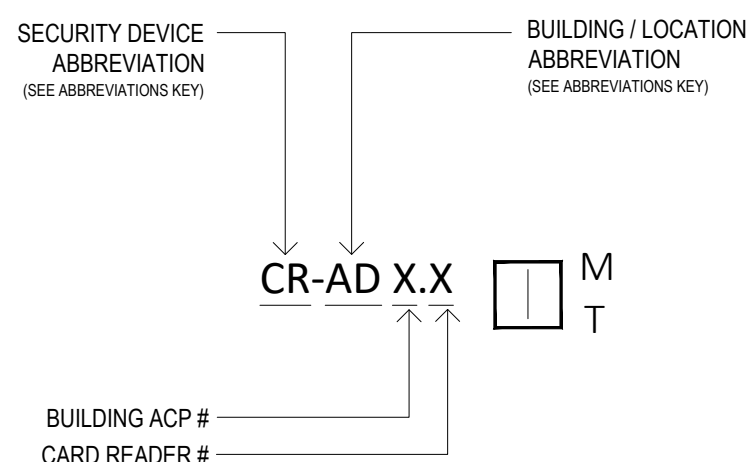
 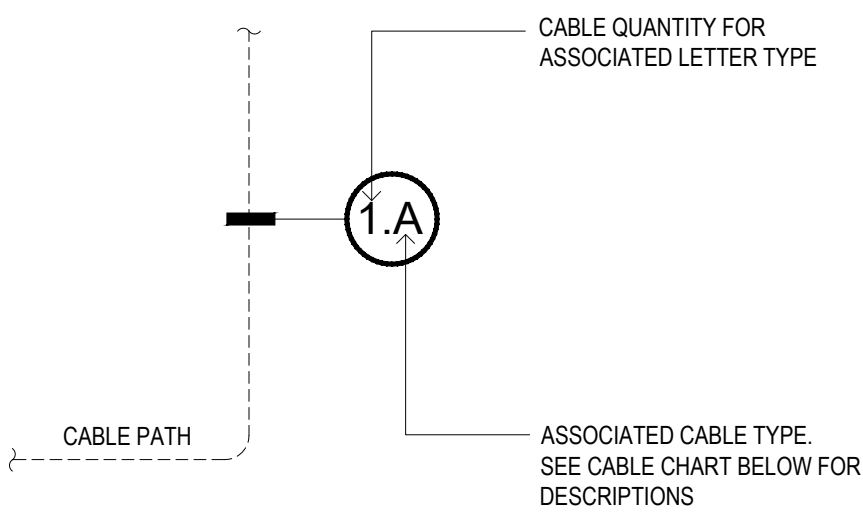


SECURITY SHOP DRAWINGS





SHEET	DESCRIPTION
ACD	ACCESS CONTROL DOOR
ACP	ACCESS CONTROL PANEL
ACS	ACCESS CONTROL SERVER
AE	APPROVED EQUAL
AFF	ABOVE FINISHED FLOOR
AFG	ABOVE FINISHED GRADE
AG	ABOVE GRADE
ALT	ALTERNATE
AR	AS REQUIRED
ARCH	ARCHITECT/ARCHITECTURAL
BSCP	BURGLAR ALARM SYSTEM CONTROL PANEL
BSIN	BURGLAR ALARM SYSTEM INPUT DEVICE
BSOUT	BURGLAR ALARM SYSTEM OUTPUT DEVICE
CKD	CHECKED
CT	CABLE TRAY
DED	DEDICATED
DN	DOWN (DIRECTIONAL)
E	EAST
ENG	ENGINEERED
ELEV	ELEVATION
GC	GENERAL CONTRACTOR
LF	LEFT (DIRECTIONAL)
MECH	MECHANICAL
N	NORTH
NE	NORTHEAST
NPL	NORTH PARKING LOT
NS	NO SUBSTITUTE
NW	NORTHWEST
OE	OR EQUIVALENT
PS	POWER SUPPLY
RT	RIGHT (DIRECTIONAL)
RM	ROOM
S	SOUTH
SE	SOUTHEAST
SW	SOUTHWEST
TYP	TYPICAL
UG	UNDERGROUND
UP	UP (DIRECTIONAL)
W	WEST
WP	WEATHER PROOF
EX	EXTERIOR
AD	ADMINISTRATION
OP	OPERATIONS
WH	WAREHOUSE
EL	ELECTRICAL
EN	ENGINEERING
PL	PLUMBING
SWH	SWITCH
IS	INTERCOM SYSTEM
ISS	INTERCOM SUB STATION
IMS	INTERCOM MASTER STATION
VSC	VIDEO SYSTEM CAMERA
VSS	VIDEO SYSTEM SERVER

SYMBOL	DEVICE NAME	TECH TYPE OPTION
	FIXED CAMERA	D = DOME A = ANALYTICS IR = INFRARED LP = LICENSE PLATE
	360 DEGREE CAMERA	D = DOME
	180 DEGREE CAMERA	D = DOME
	VIDEO RECORDER	N = NETWORK A = ANALOG D = DIGITAL H = HYBRID
	CRASH BAR	E = CRASH BAR EX = CRASH BAR WITH EXIT D = DELAYED EGRESS
	CONTROL PANEL	AC = ACCESS CONTROL PANEL B = BURGLAR F = FIRE E = ELEVATOR
	NETWORK SWITCH	N = NETWORK P = POWER OVER ETHERNET
	UPS	
	AUDIO	A = AUDIO AKS = AUDIO WITH KEY SWITCH S = SOUNDER
	POWER SUPPLY	AC = ACCESS CONTROL VM = VIDEO MANAGEMENT B = BURGLAR
	WIRELESS RECEIVER	AC = ACCESS CONTROL B = BURGLAR N = NETWORK E = VIDEO
	SERVER / WORKSTATION	AC = ACCESS CONTROL VM = VIDEO MANAGEMENT C = COM AR = AUDIO RECORDER AP = ANALYTIC PROCESSOR
	INTERCOM	ISS = INTERCOM SUB STATION IMS = INTERCOM MASTER STATION
	LED DISPLAY SIGN	O = OCCUPIED SIGNAGE
	STATUS LIGHT	L = LED S = STROBE
	PHOTO BEAM	PB = PHOTO BEAM MW = MICROWAVE IR = INFRARED MS = MONO STATIC T = TRANSMIT R = RECIEVE
	POWER SUPPLY	110 = 110 VAC 120 = 120 VAC 240 = 240 VAC

SYMBOL	DEVICE NAME	TECH TYPE OPTION
 M T	CARD READER	P = PROXIMITY MS = MAG SWIPE WE = WIEGANG B = BARCODE S = SMART
 P	CARD READER: PROXIMITY	P = PROXIMITY W = WALL MOUNT
 DC	DOOR CONTACT	S = SURFACE MOUNT
 M T	SWITCH	AC = ALARM CONTACT WAC = WIRELESS ALARM CONTACT DC = DOOR CONTACT ACP = ACCESS FAIL WDC = WIRELESS DOOR CONTACT TS = TAILGATE SENSOR T = TAMPER VS = VIBRATION SENSOR P = POWER FAIL
 M T	ACCESS BUTTON	ER = EMERGENCY DOOR RELEASE D = DURESS RDR = REMOTE DOOR RELEASE RTE = REQUEST-TO-EXIT HPP = HANDICAP PUSH PANEL EX = EXIT BUTTON
 M RTE	RTE PUSH BUTTON	RTE = REQUEST TO EXIT W = WALL MOUNT
	ELECTRIFIED HINGE	
 M T	ELECTRIFIED LOCKSET	L = LEVER LOCK S = STRIKE LOCK MA = MAGNETIC LOCK
 L	ELECTRIFIED LEVER LOCK WITH REX IN HANDLE	L = LEVER LOCK
 S	ELECTRIFIED STRIKE LOCK	H = HEADER MOUNT
 MA	ELECTRIFIED MAGNETIC LOCK	MA = MAGNETIC LOCK
 M T	MOTION DETECTOR	P = PASSIVE INFRARED READER R = REQUEST-TO-EXIT
 R	MOTION DETECTOR - REX	R = REQUEST-TO-EXIT W = WALL MOUNT
 P	MOTION DETECTOR - PIR	P = PASSIVE INFRARED READER W = WALL MOUNT
 M T	FIELD PANEL	AC = ACCESS CONTROL PANEL B = BURGLAR F = FIRE E = ELEVATOR G = GATE CONTROL P = ELEVATOR
 AC	FIELD PANEL: ACCESS CONTROL	AC = ACCESS CONTROL PANEL W = WALL MOUNT

SHEET	DESCRIPTION
E50 0	TITLE SHEET
E50 1	DEVICE SCHEDULES
E51 0	LEVEL 1- SECURITY PLAN
E52 0	TYPICAL SECURITY DOOR DETAILS
E52 1	TYPICAL CAMERA MOUNT DETAILS
E52 2	ACCESS CONTROL COMPONENT DETAILS
E53 0	SECURITY HEADEND ELEVATIONS
E54 0	ACCESS CONTROL POINT-TO-POINTS
E55 0	ACCESS CONTROL & VIDEO SYSTEM RISER DIAGRAMS
E56 0	ACCESS CONTROL SYSTEM BLOCK DIAGRAM

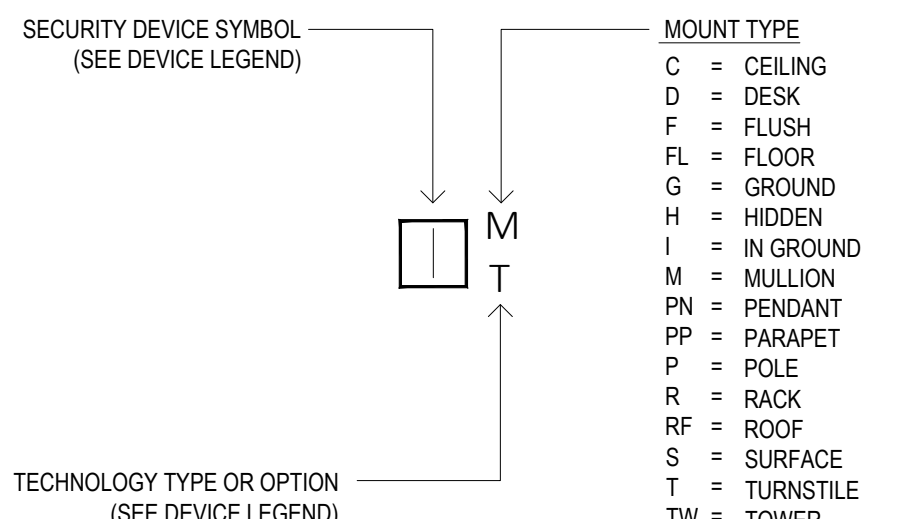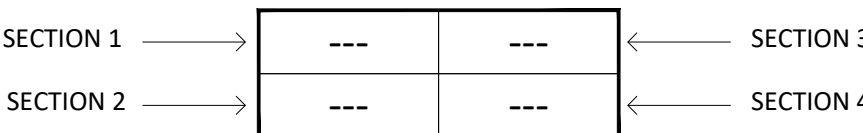

LETTER	CABLE TYPE / DESCRIPTION
A	COMPOSITE PLENUM CABLE
B	22/4 STRANDED PLENUM CABLE
C	18/2 STRANDED PLENUM CABLE
D	18/6 STRANDED PLENUM CABLE
T	CAT6

COLOR	DESCRIPTION
● GREEN	EXISTING ACCESS CONTROL DEVICE(S)
● BLUE	NEW ACCESS CONTROL DEVICE(S)
● PURPLE	EXISTING ALARM DEVICE(S)
● PINK	NEW ALARM DEVICE(S)
● MAGENTA	EXISTING INTERCOM DEVICE(S)
● LIGHT BLUE	NEW INTERCOM DEVICE(S)
● YELLOW	EXISTING CAMERA(S) AND VIDEO DEVICE(S)
● RED	NEW CAMERA(S) AND VIDEO DEVICE(S)
● BLACK	EXISTING DEVICE(S) AND RELATED CABLING TO BE REMOVED

ABV.	DEVICE TYPE CALL-OUT
ACS	ACCESS CONTROL SERVER
ACP	ACCESS CONTROL PANEL
ACD	ACCESS CONTROL DOOR
ACIN	ACCESS CONTROL INPUT DEVICE
ACOUT	ACCESS CONTROL OUTPUT DEVICE
VSS	VIDEO SYSTEM SERVER
VSC	VIDEO SYSTEM CAMERA
FSCP	FIRE SYSTEM CONTROL PANEL
FSIN	FIRE SYSTEM INPUT DEVICE
FSOUT	FIRE SYSTEM OUTPUT DEVICE
BSCP	BURG SYSTEM CONTROL PANEL
BSIN	BURG SYSTEM INPUT DEVICE
BSOUT	BURG SYSTEM OUTPUT DEVICE
IS	INTERCOM SYSTEMS

SECTION 2

FLOOR NUMBER AND COUNT

- FIRST TWO NUMBERS = FLOOR NUMBER
- LAST FOUR NUMBERS = COUNT FOR THAT DEVICE TYPE ON THAT LISTED FLOOR.

SECTION 3

POINT OF CONNECTION CALLOUT

- SERVER, PANEL, OR SWITCH THAT THE DEVICE IS CONNECTED TO.

CABLE PACKAGE CALLOUT

- TYPE OF CABLE PACKAGE TO BE USED.

SECURITY GROUP NAME

ACCESS CONTROL \ IP VIDEO SYSTEMS

SAMPLE SECURITY DRAWINGS

STREET ADDRESS

JOB NO.:

DRAWN: S.ESTES

ENG/CKD

DATE:

SCALE:

ET TITLE:



TITLE SHEET

SHEET NUMBER

ES0.0



[illegible][illegible]

REV.		DATE	DESCRIPTION
SECURITY GROUP NAME			
STREET ADDRESS			
CITY, STATE & ZIP			
ACCESS CONTROL \ IP VIDEO SYSTEMS			
SAMPLE SECURITY SUBMITTAL			
SAMPLE SECURITY DRAWINGS			
STREET ADDRESS			
CITY, STATE & ZIP			
JOB NO.:			
DRAWN: S. ESTES			
ENG/CKD:			
DATE:			
SCALE:			
SHEET TITLE:			
SECURITY DEVICE SCHEDULE			
SHEET NUMBER:			
ES0.1			

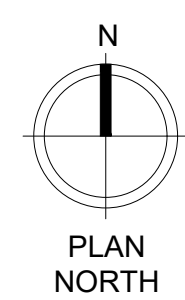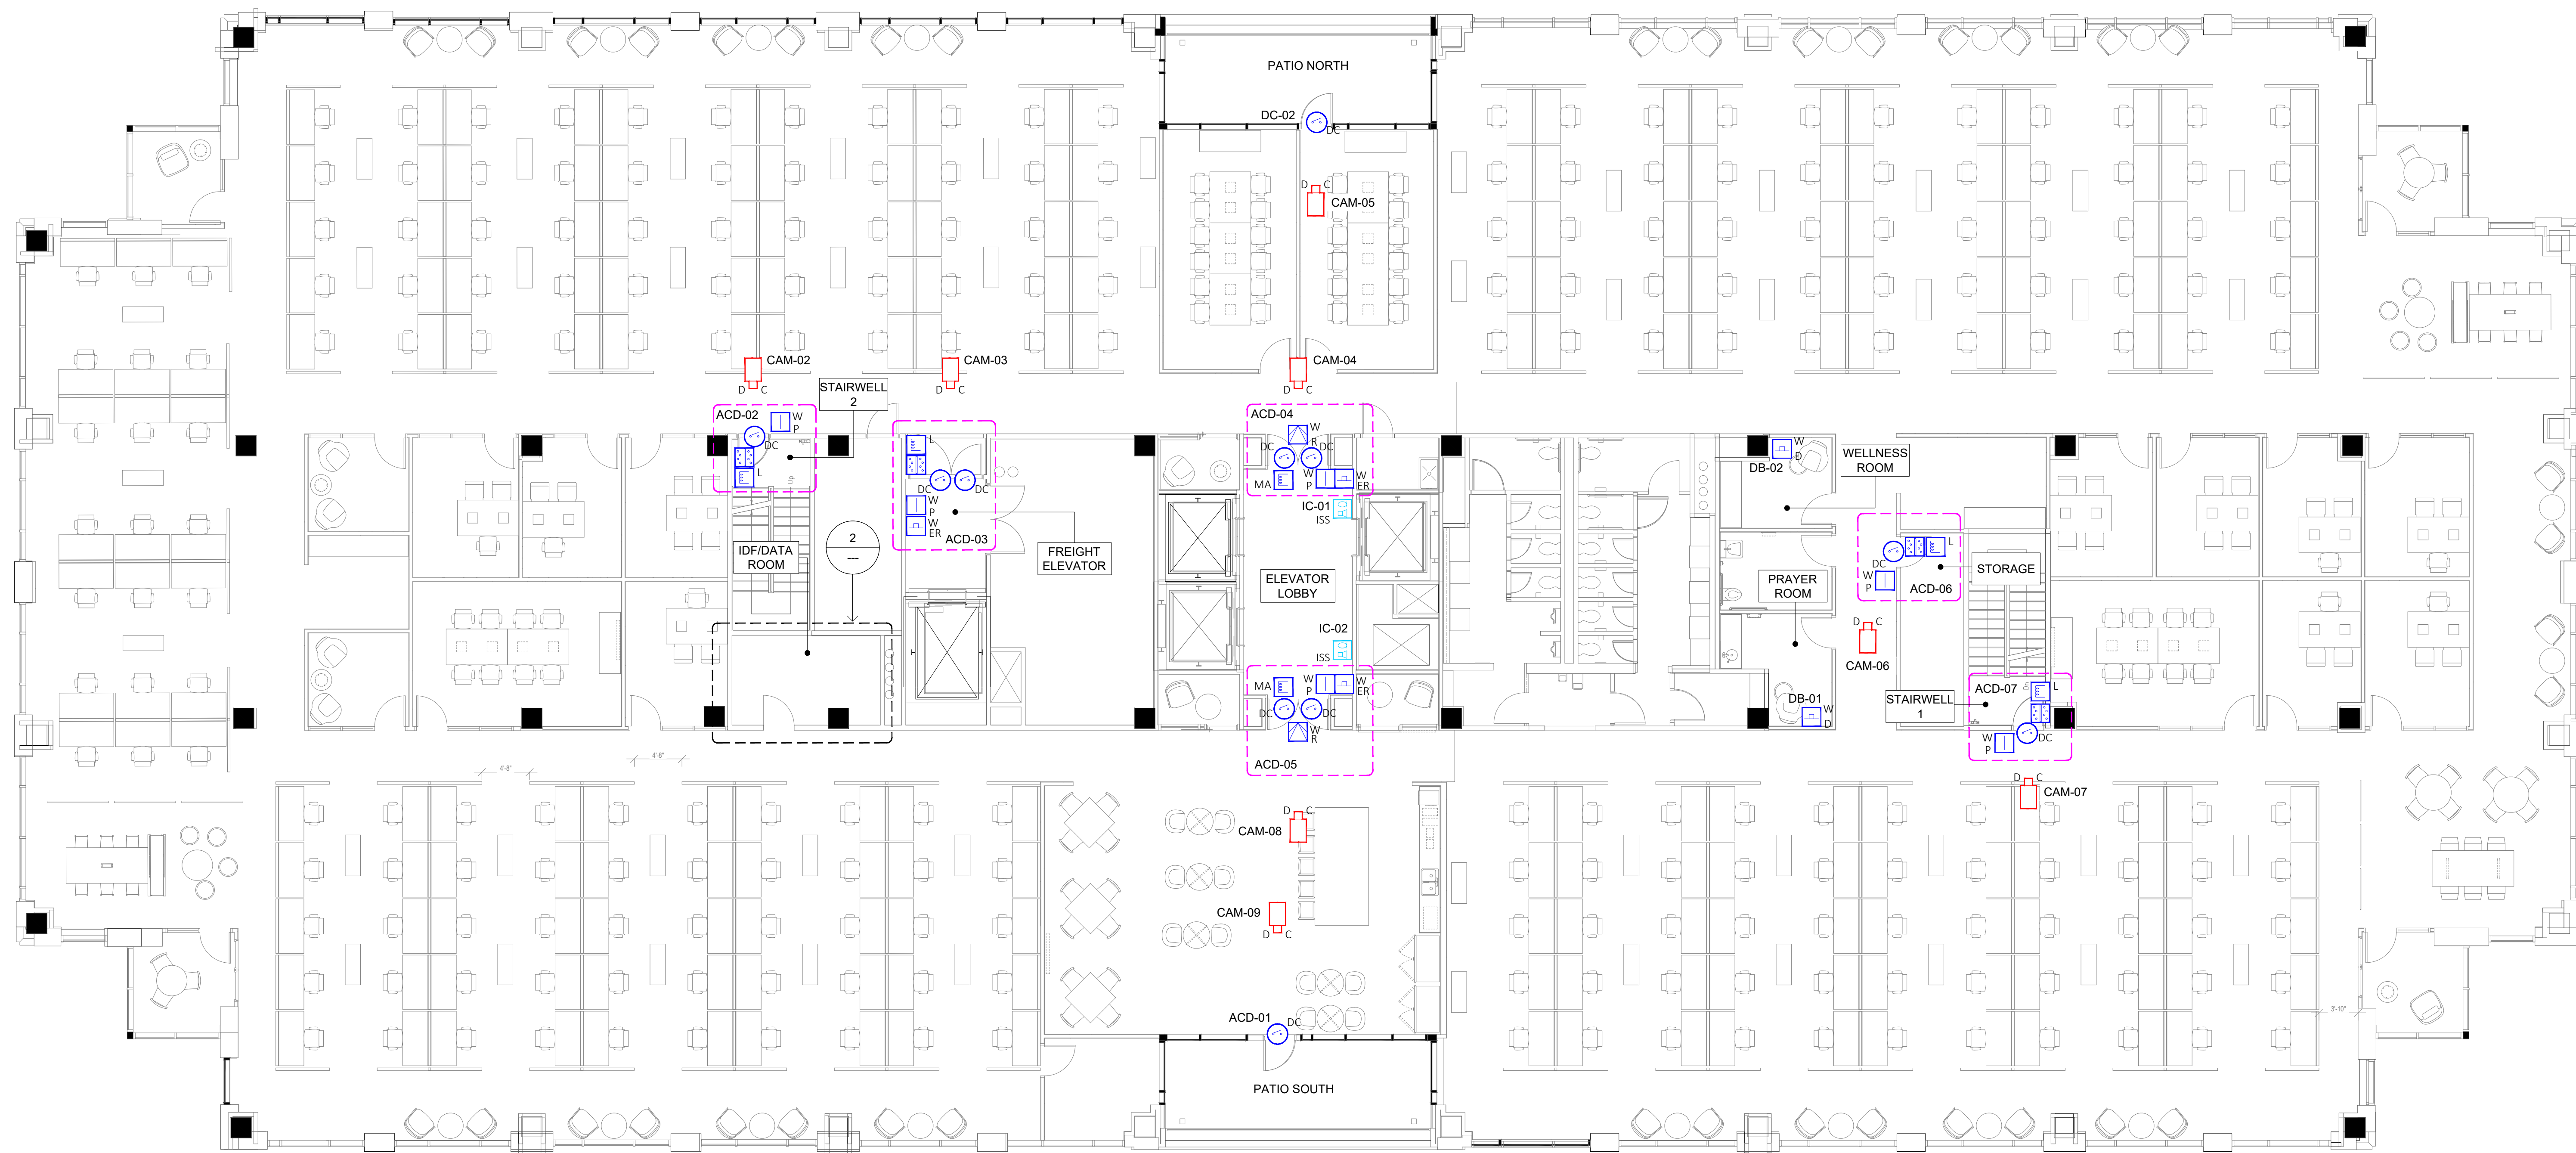

FLOOR PLAN

SCALE: 1/8"=1'-0"

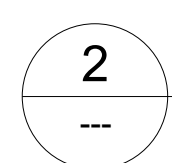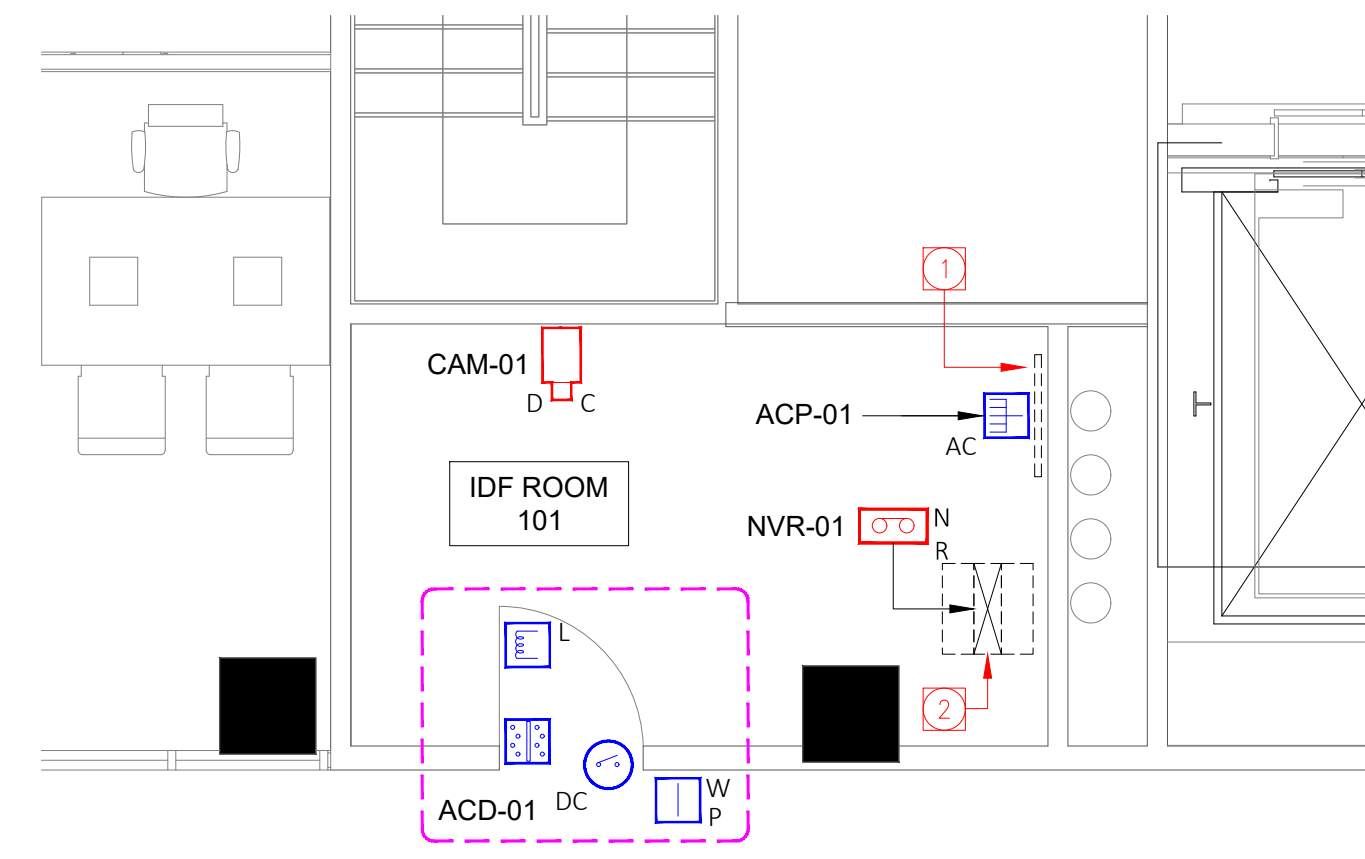

PARTIAL PLAN AT IDF ROOM 101

SCALE: 1/4"=1'-0"

SECURITY NOTES	
☐	DESCRIPTION
1	ACCESS CONTROL BACKBOARD
2	VIDEO RACK WITH NETWORK VIDEO RECORDER

REV	DATE	DESCRIPTION

SECURITY GROUP NAME

STREET ADDRESS
CITY, STATE & ZIP

ACCESS CONTROL \ IP VIDEO SYSTEMS
SAMPLE SECURITY SUBMITTAL

SAMPLE SECURITY DRAWINGS

STREET ADDRESS
CITY, STATE & ZIP


JOB NO.:	
DRAWN: S.ESTES	
ENG/CKD:	
DATE:	
SCALE: 1/8"=1'-0"	
SHEET TITLE:	

LEVEL 1
SECURITY PLAN

SHEET NUMBER:


ES1.0

DOOR TYPE	SECURITY DEVICES			CABLE TYPES	
> SINGLEWOOD/METAL > HAND ON RIGHT SIDE > DOOR SWINGS IN DEVICE CABLE ROUTING > ALL DOOR COMPONENTS HOME RUN ACCESS CONTROL PANEL	SYM	QTY	DESCRIPTION	(X)	DESCRIPTION
	(C)	1	DOOR CONTACT	(H)	18/2 STRANDED PLENUM CABLE

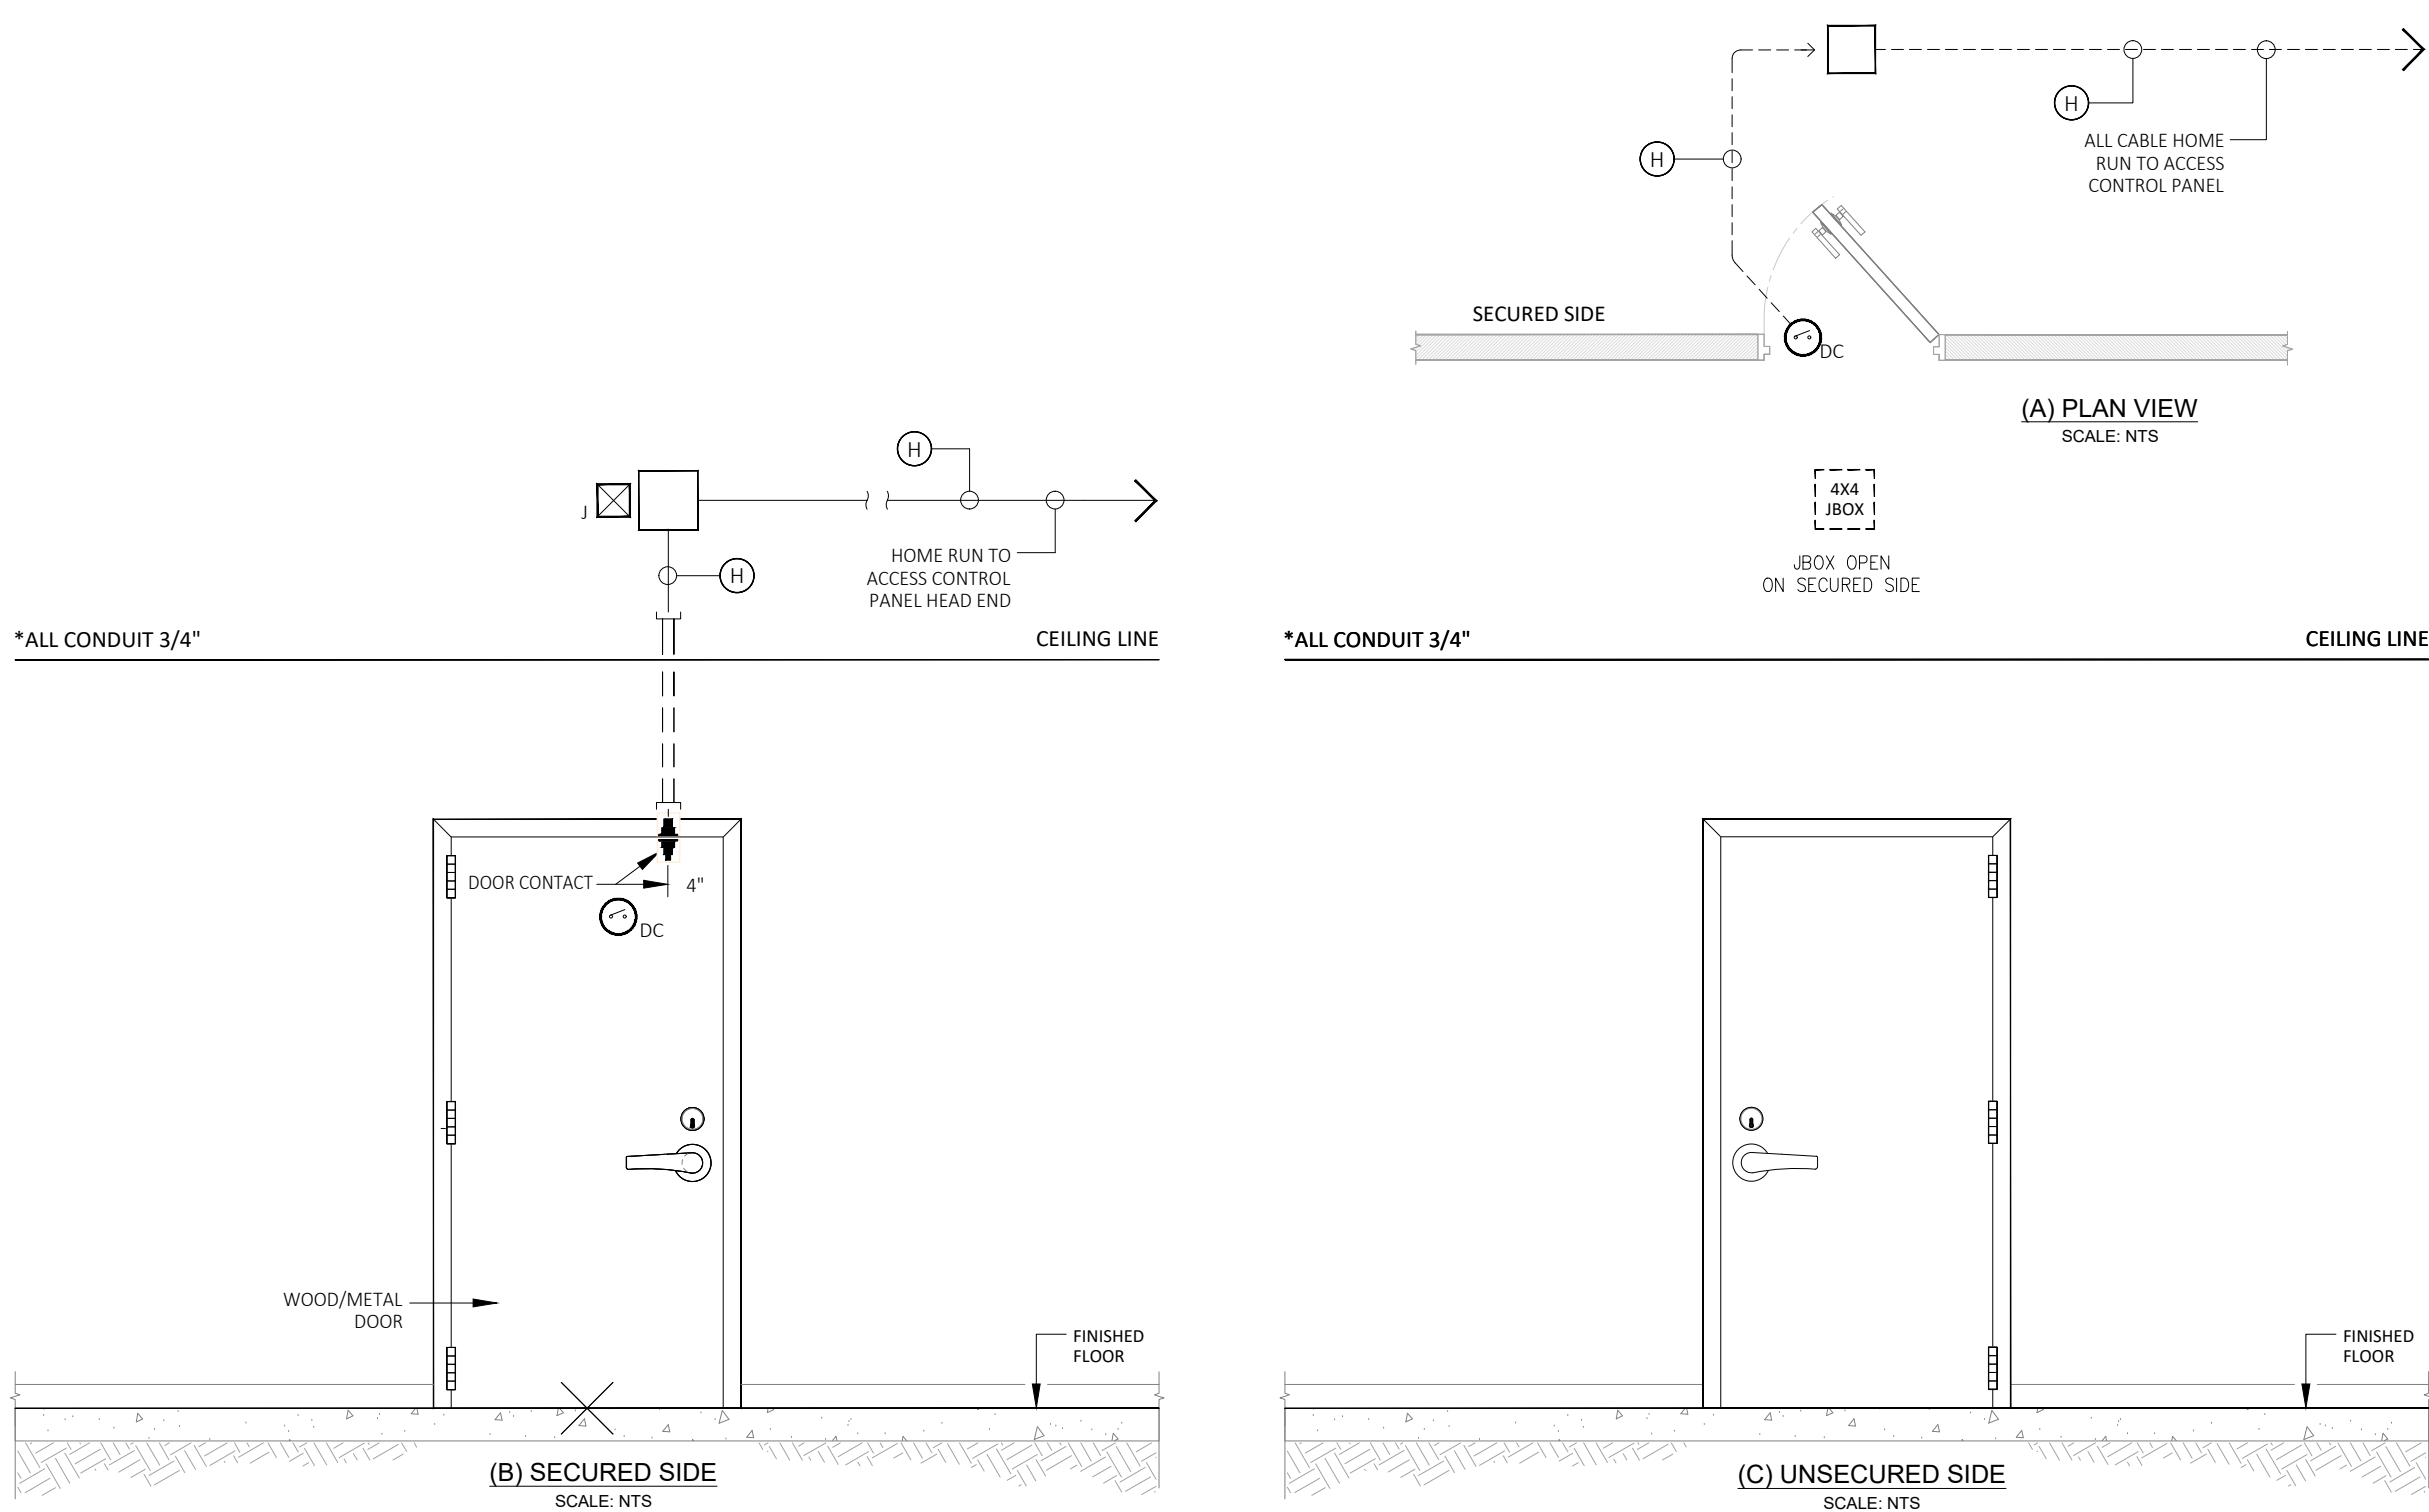


1 SINGLE STANDARD TYPE SECURITY DOOR NON-ELECTRIFIED LOCKING HARDWARE WITH A FREE-EGRESS SCENARIO INCLUDING: (1) DOOR CONTACT
SCALE: T.S.

DOOR TYPE	SECURITY DEVICES			CABLE TYPES	
> SINGLEWOOD/METAL > HAND ON RIGHT SIDE > DOOR SWINGS IN DEVICE CABLE ROUTING > ALL DOOR COMPONENTS HOME RUN ACCESS CONTROL PANEL	SYM	QTY	DESCRIPTION	(X)	DESCRIPTION
	(C)	1	DOOR CONTACT	(A)	COMPOSITE CABLE PLENUM
	(D)	1	CARD READERS	(D)	22/4 STRANDED PLENUM CABLE

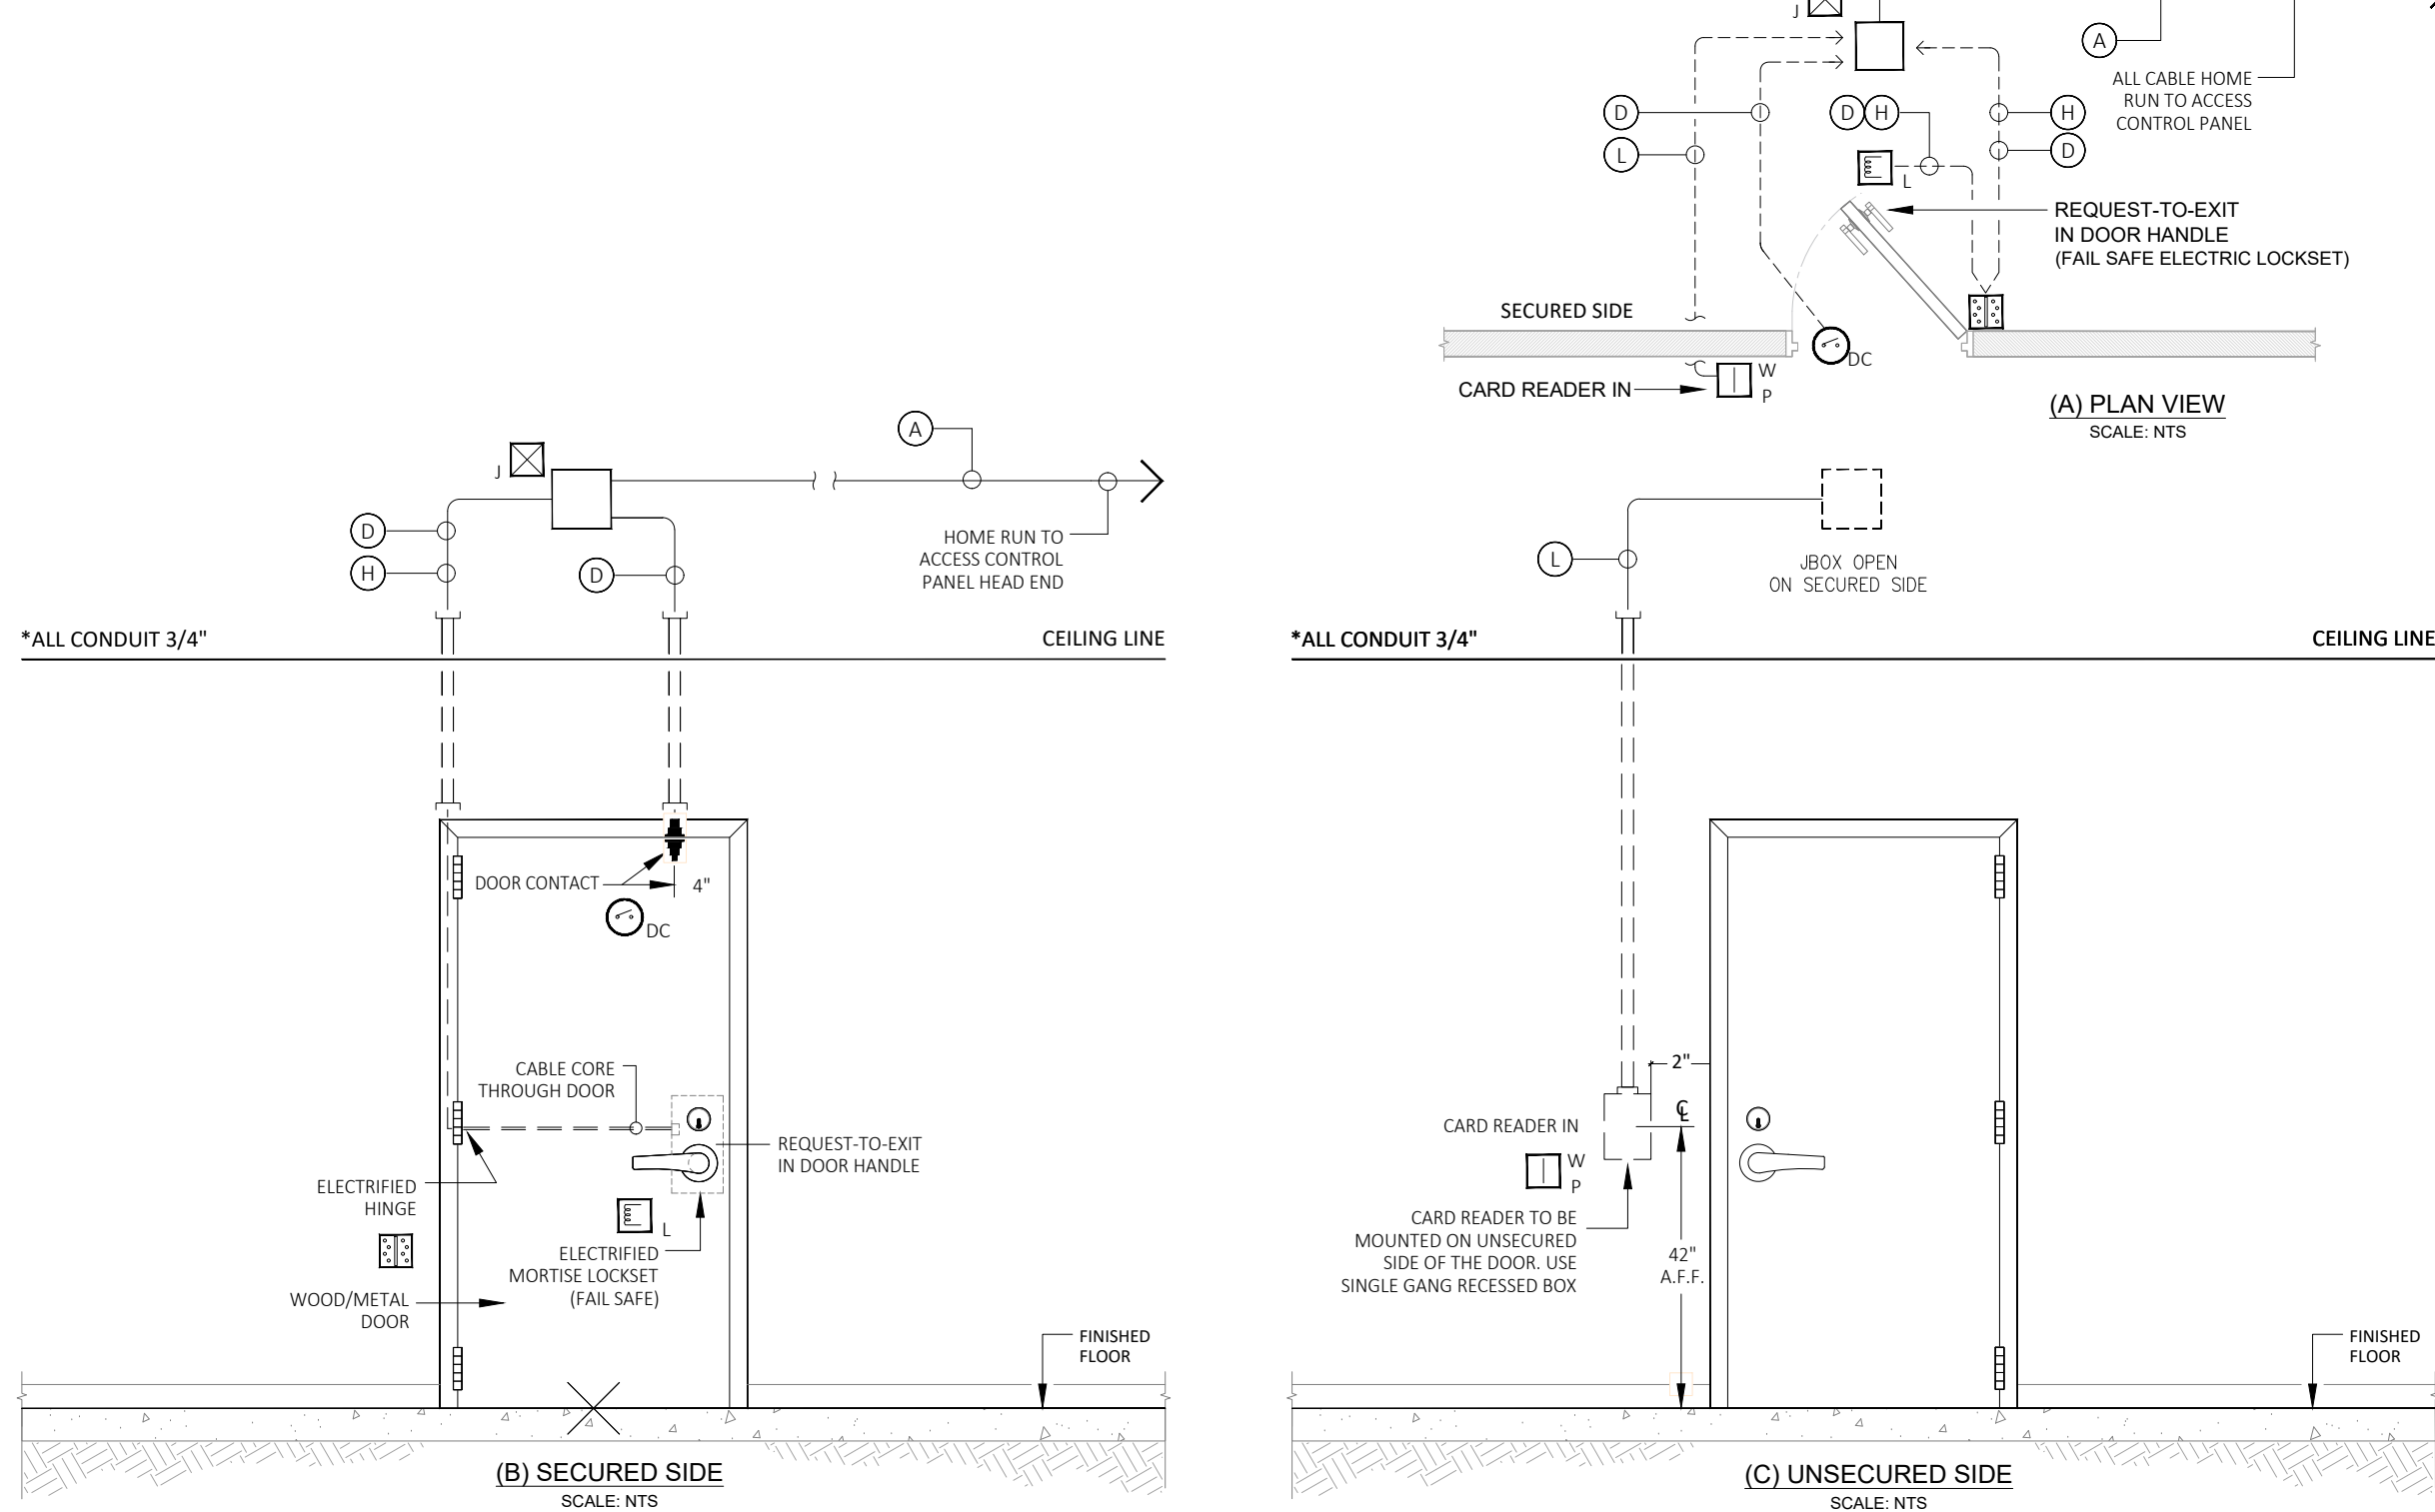


2 SINGLE STANDARD TYPE SECURITY DOOR, WITH A CARD-IN SCENARIO INCLUDING:
AN ELECTRIFIED MORTISE LOCKSET WITH INTEGRATED RTE, (1) ELECTRIFIED HINGE (1) CARD READER, AND A DOOR CONTACT
SCALE: T.S.

DOOR TYPE	SECURITY DEVICES			CABLE TYPES	
> SINGLEWOOD/METAL > HAND ON RIGHT SIDE > DOOR SWINGS IN DEVICE CABLE ROUTING > ALL DOOR COMPONENTS HOME RUN ACCESS CONTROL PANEL	SYM	QTY	DESCRIPTION	(X)	DESCRIPTION
	(C)	2	DOOR CONTACTS	(A)	COMPOSITE PLENUM CABLE
	(D)	1	CARD READER	(L)	18/6 STRANDED PLENUM CABLE

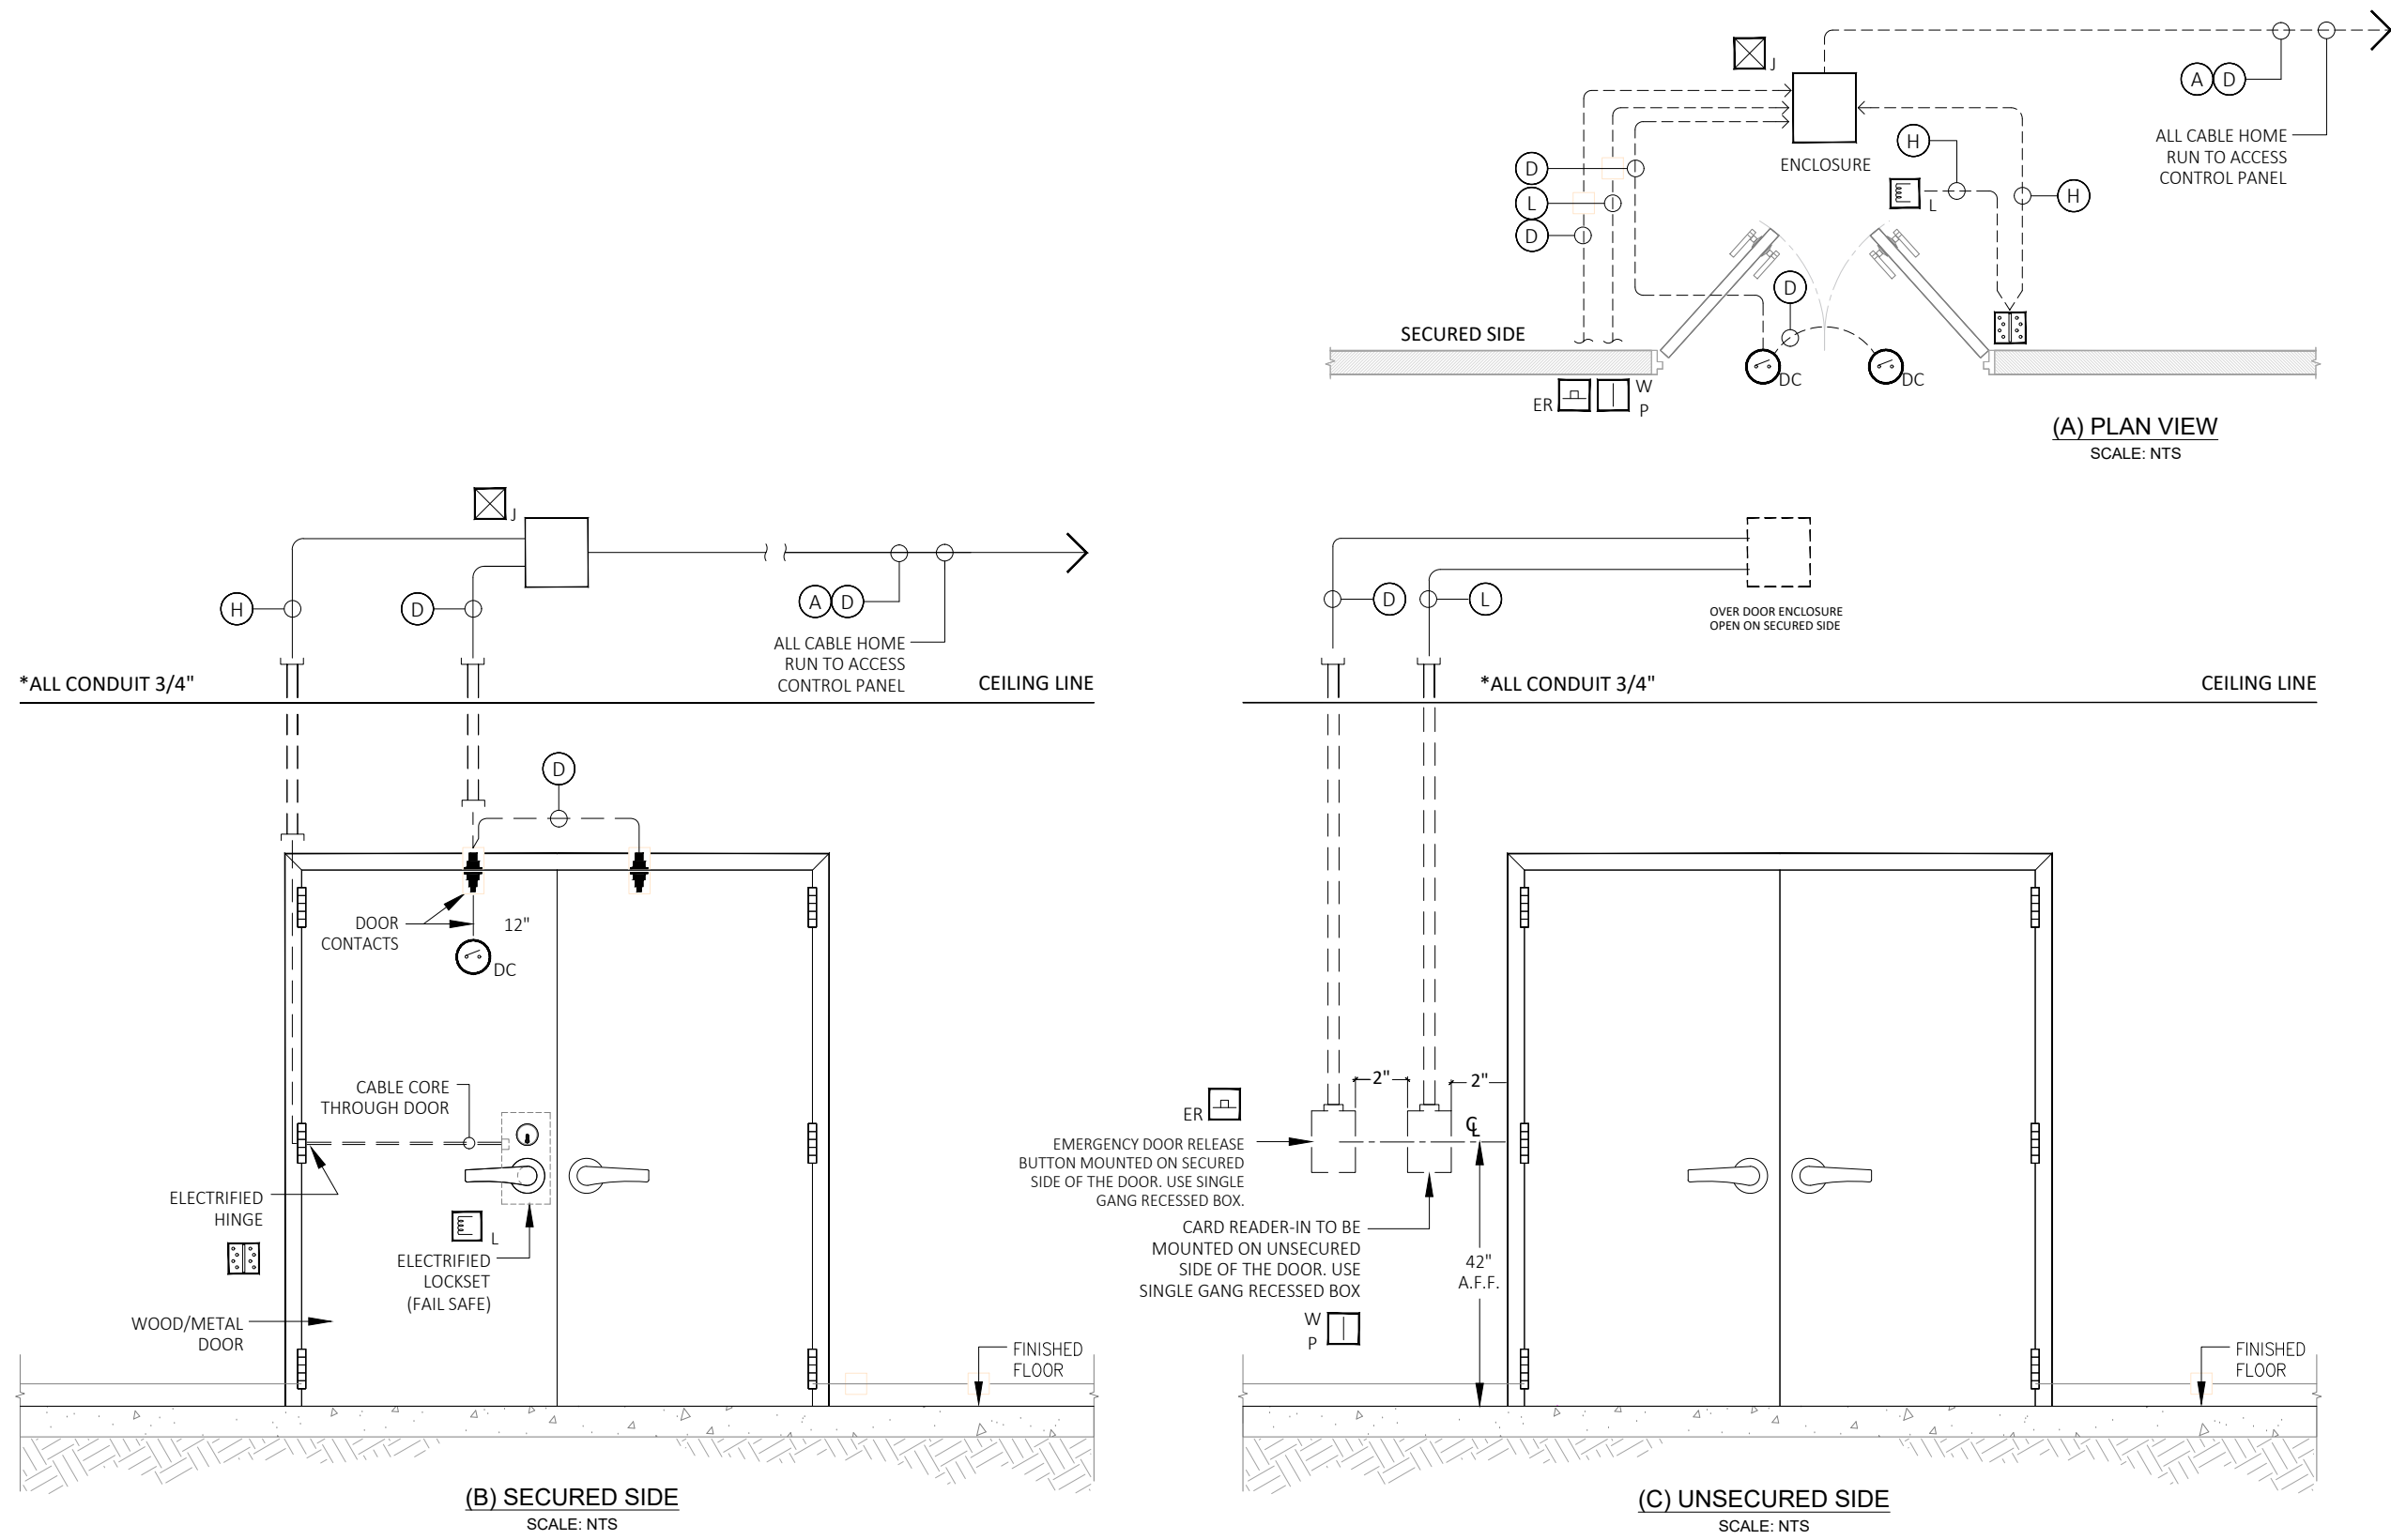

3 DOUBLE STANDARD TYPE SECURITY DOORS,
WITH A CARD-IN SCENARIO INCLUDING AN ELECTRIFIED LOCKSET, (1) CARD READER, (2) DOOR CONTACTS, AND (1) EMERGENCY DOOR RELEASE BUTTON
SCALE: T.S.

DOOR TYPE	SECURITY DEVICES			CABLE TYPES	
> SINGLEWOOD/METAL > HAND ON RIGHT SIDE > DOOR SWINGS IN DEVICE CABLE ROUTING > ALL DOOR COMPONENTS HOME RUN ACCESS CONTROL PANEL	SYM	QTY	DESCRIPTION	(X)	DESCRIPTION
	(C)	2	DOOR CONTACTS	(A)	COMPOSITE PLENUM CABLE
	(D)	1	CARD READER	(L)	18/6 STRANDED PLENUM CABLE

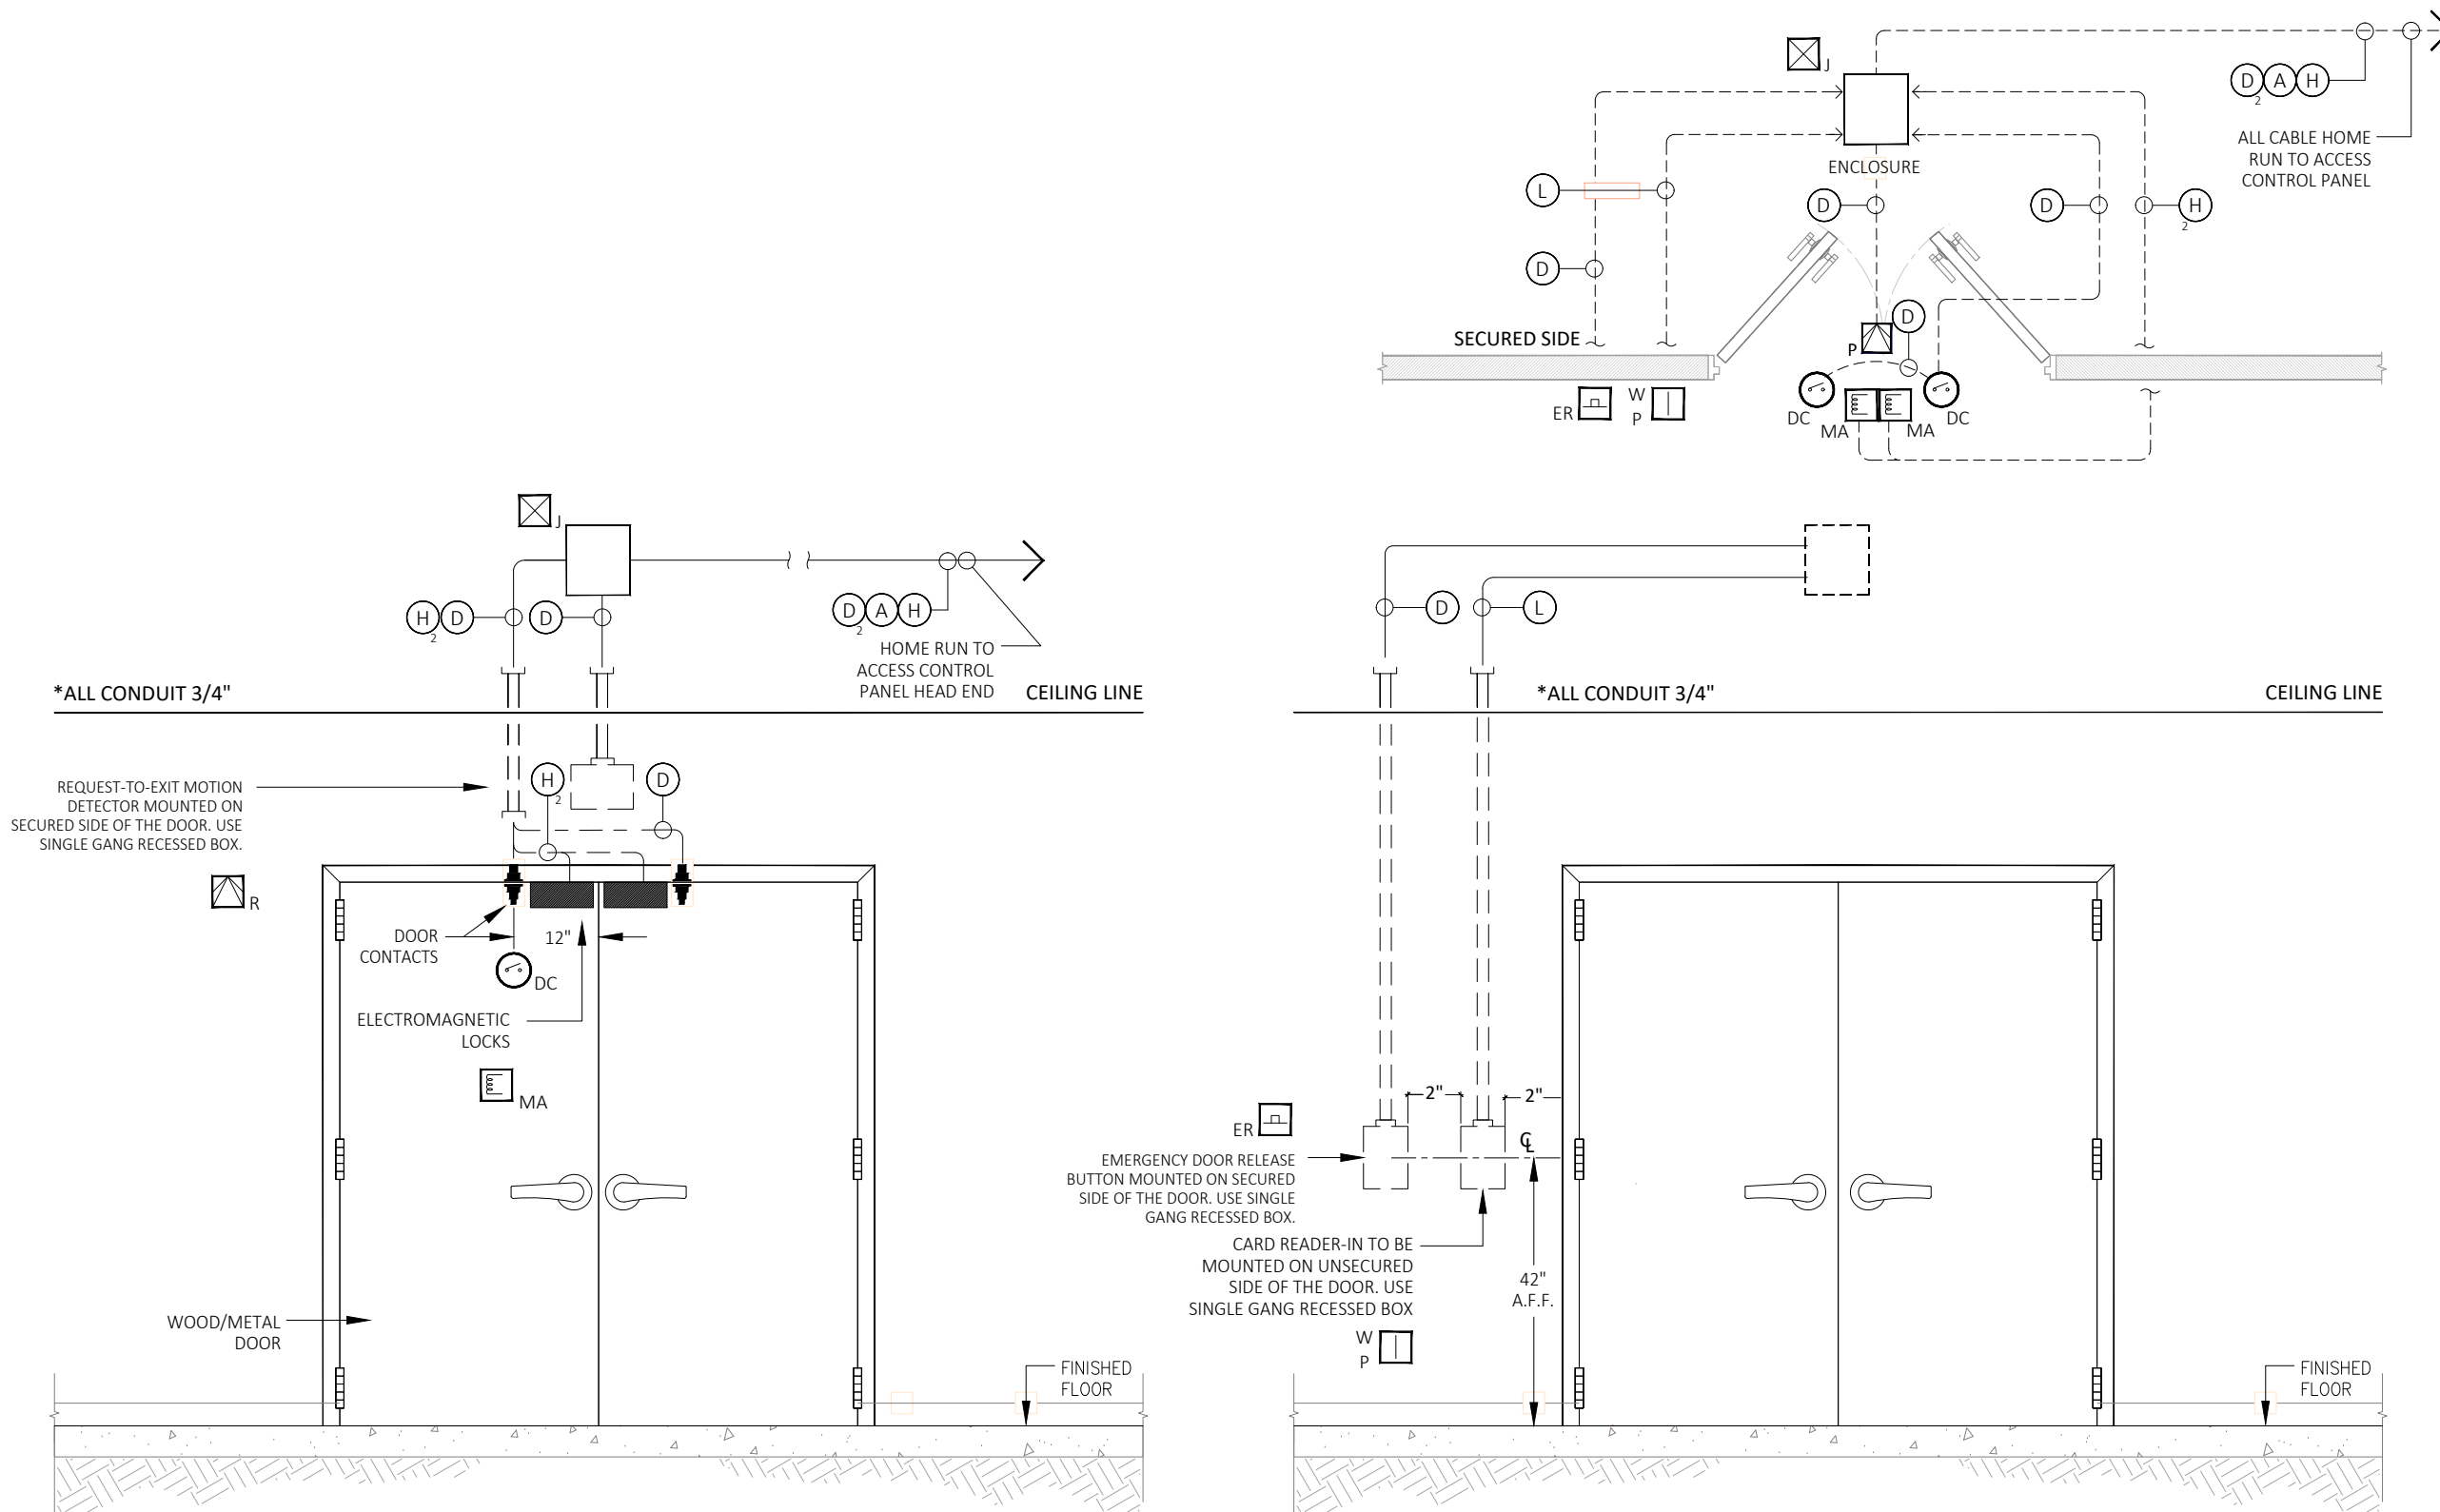

4 DOUBLE STANDARD TYPE SECURITY DOORS, WITH A CARD-IN SCENARIO INCLUDING:
(2) ELECTROMAGNETIC LOCKS, (1) CARD READER, (2) DOOR CONTACTS, (1) REQUEST-TO-EXIT PIR, AND (1) EMERGENCY DOOR RELEASE BUTTON
SCALE: T.S.

REV DATE DESCRIPTION

SECURITY GROUP NAME
STREET ADDRESS
CITY, STATE & ZIP


ACCESS CONTROL IP VIDEO SYSTEMS
SAMPLE SECURITY SUBMITTAL

SAMPLE SECURITY DRAWINGS
STREET ADDRESS
CITY, STATE & ZIP


JOB NO.:
DRAWN: S. ESTES
ENG'CKD:
DATE:
SCALE:

SHEET TITLE:
TYPICAL SECURITY
DOOR DETAILS


SHEET NUMBER:
ES2.0

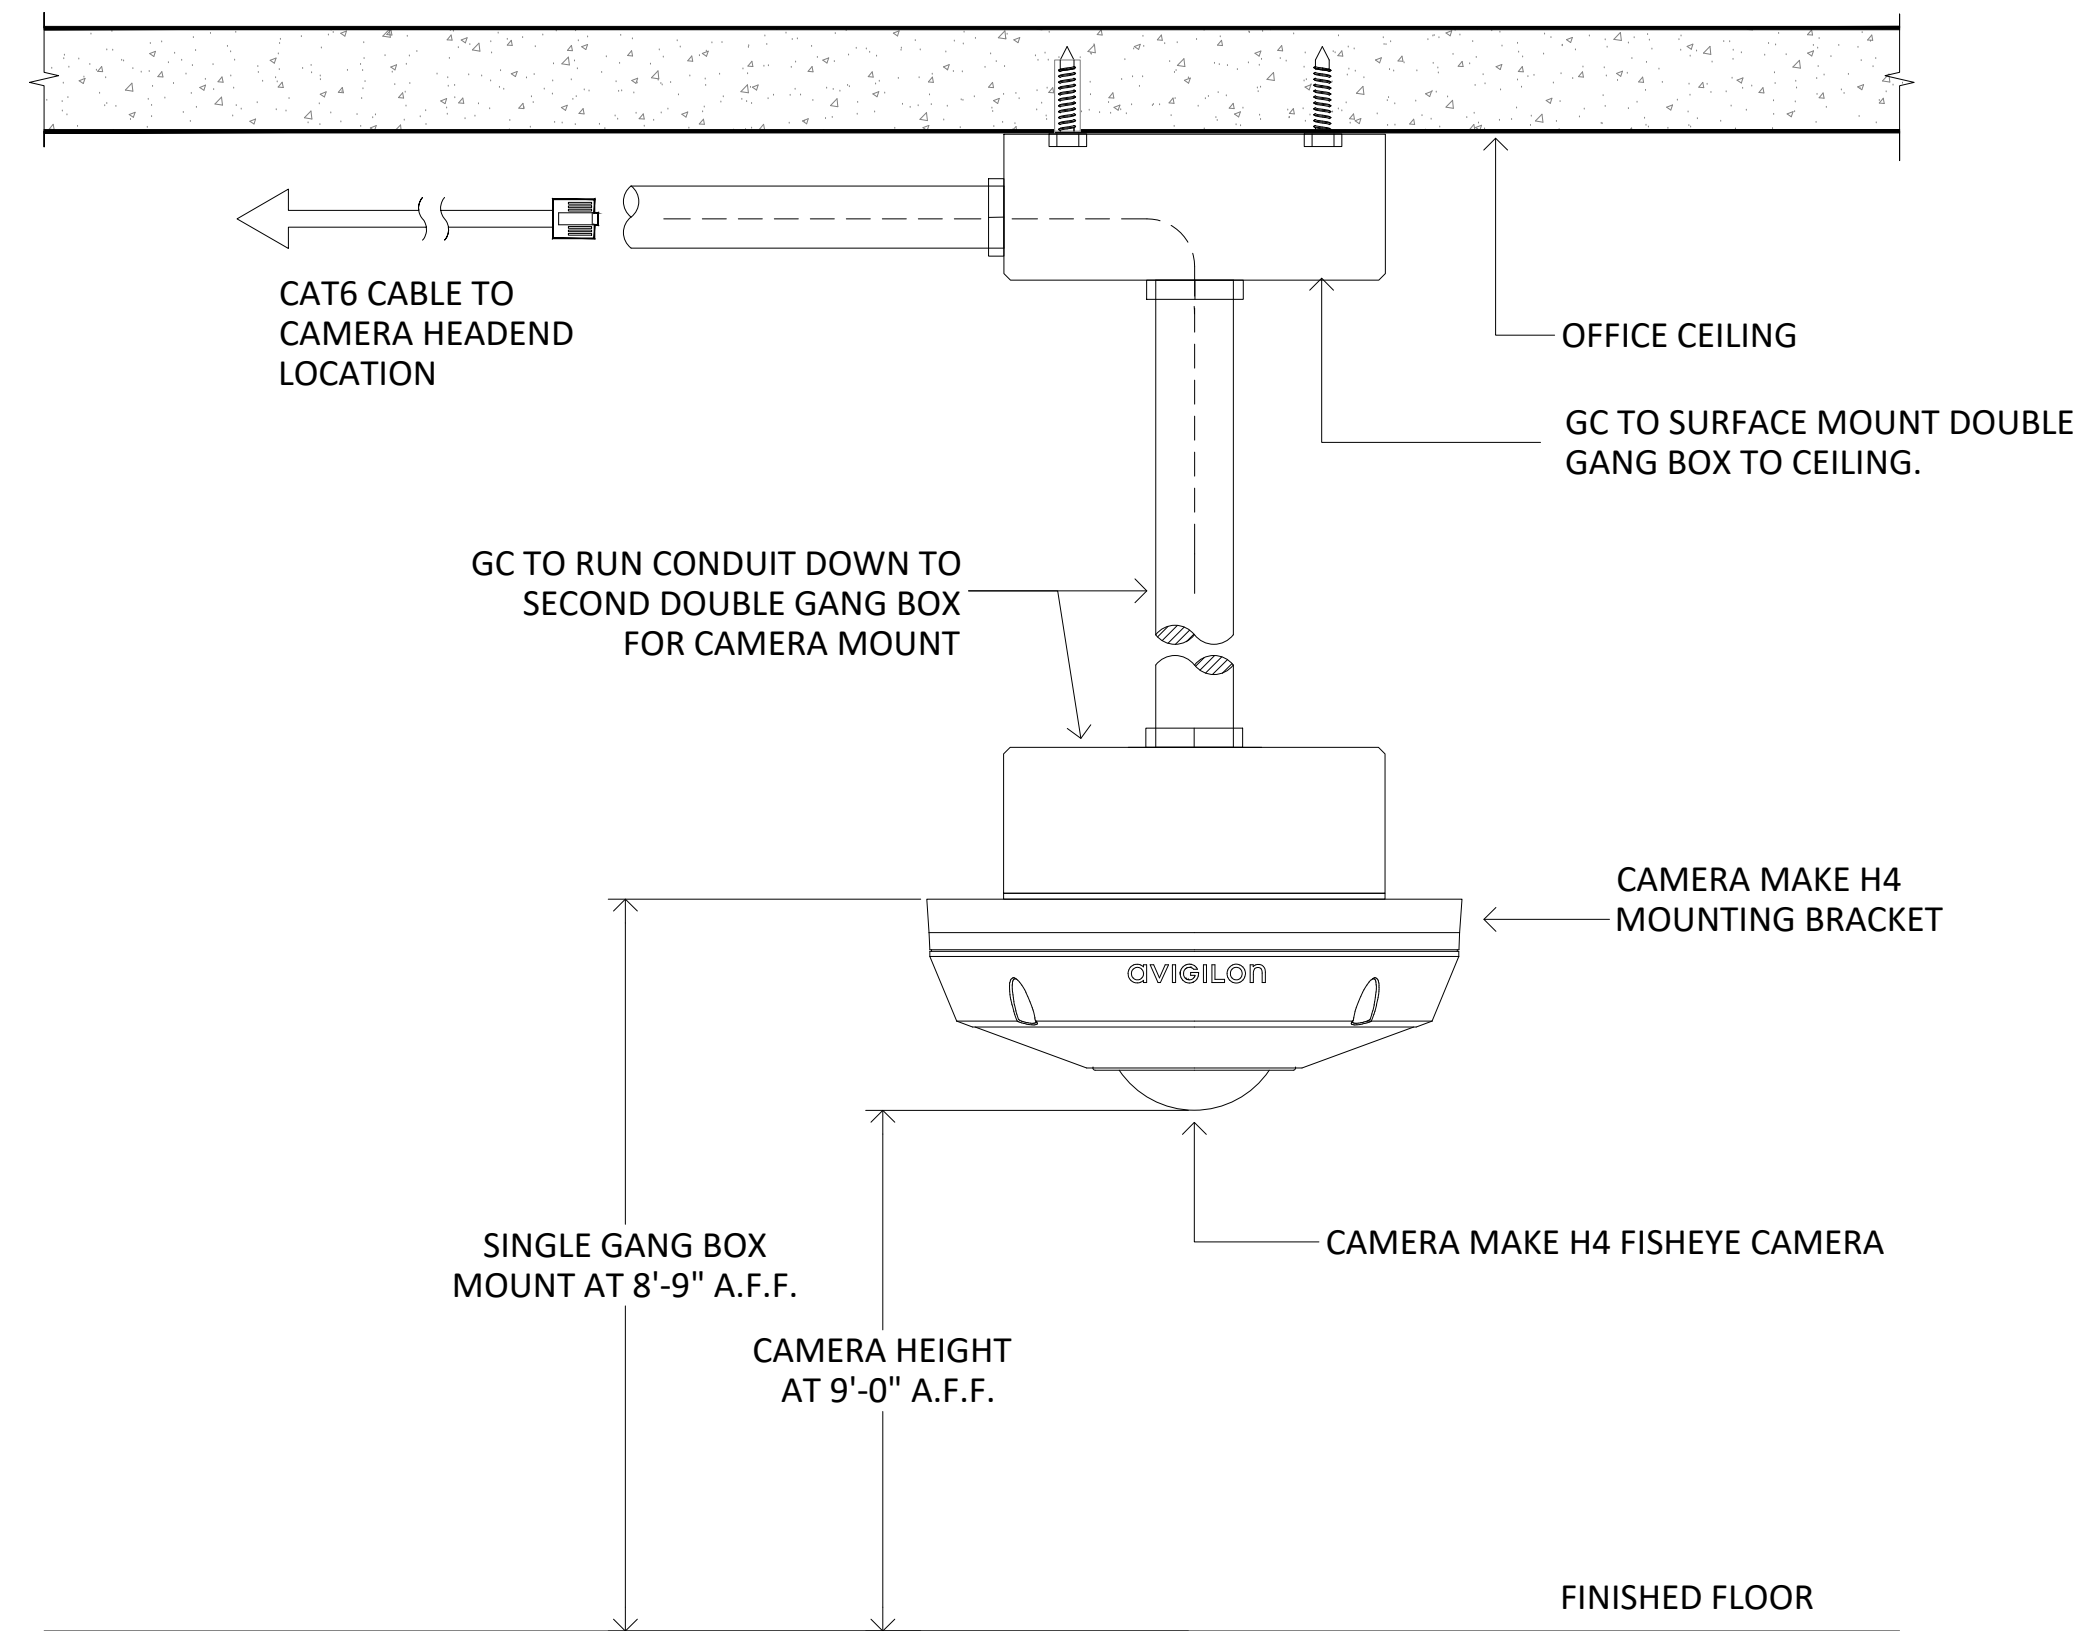


1 DETAIL - TYPICAL H4 DOME CAMERA PENDANT CEILING MOUNT
--- SCALE: T.S.

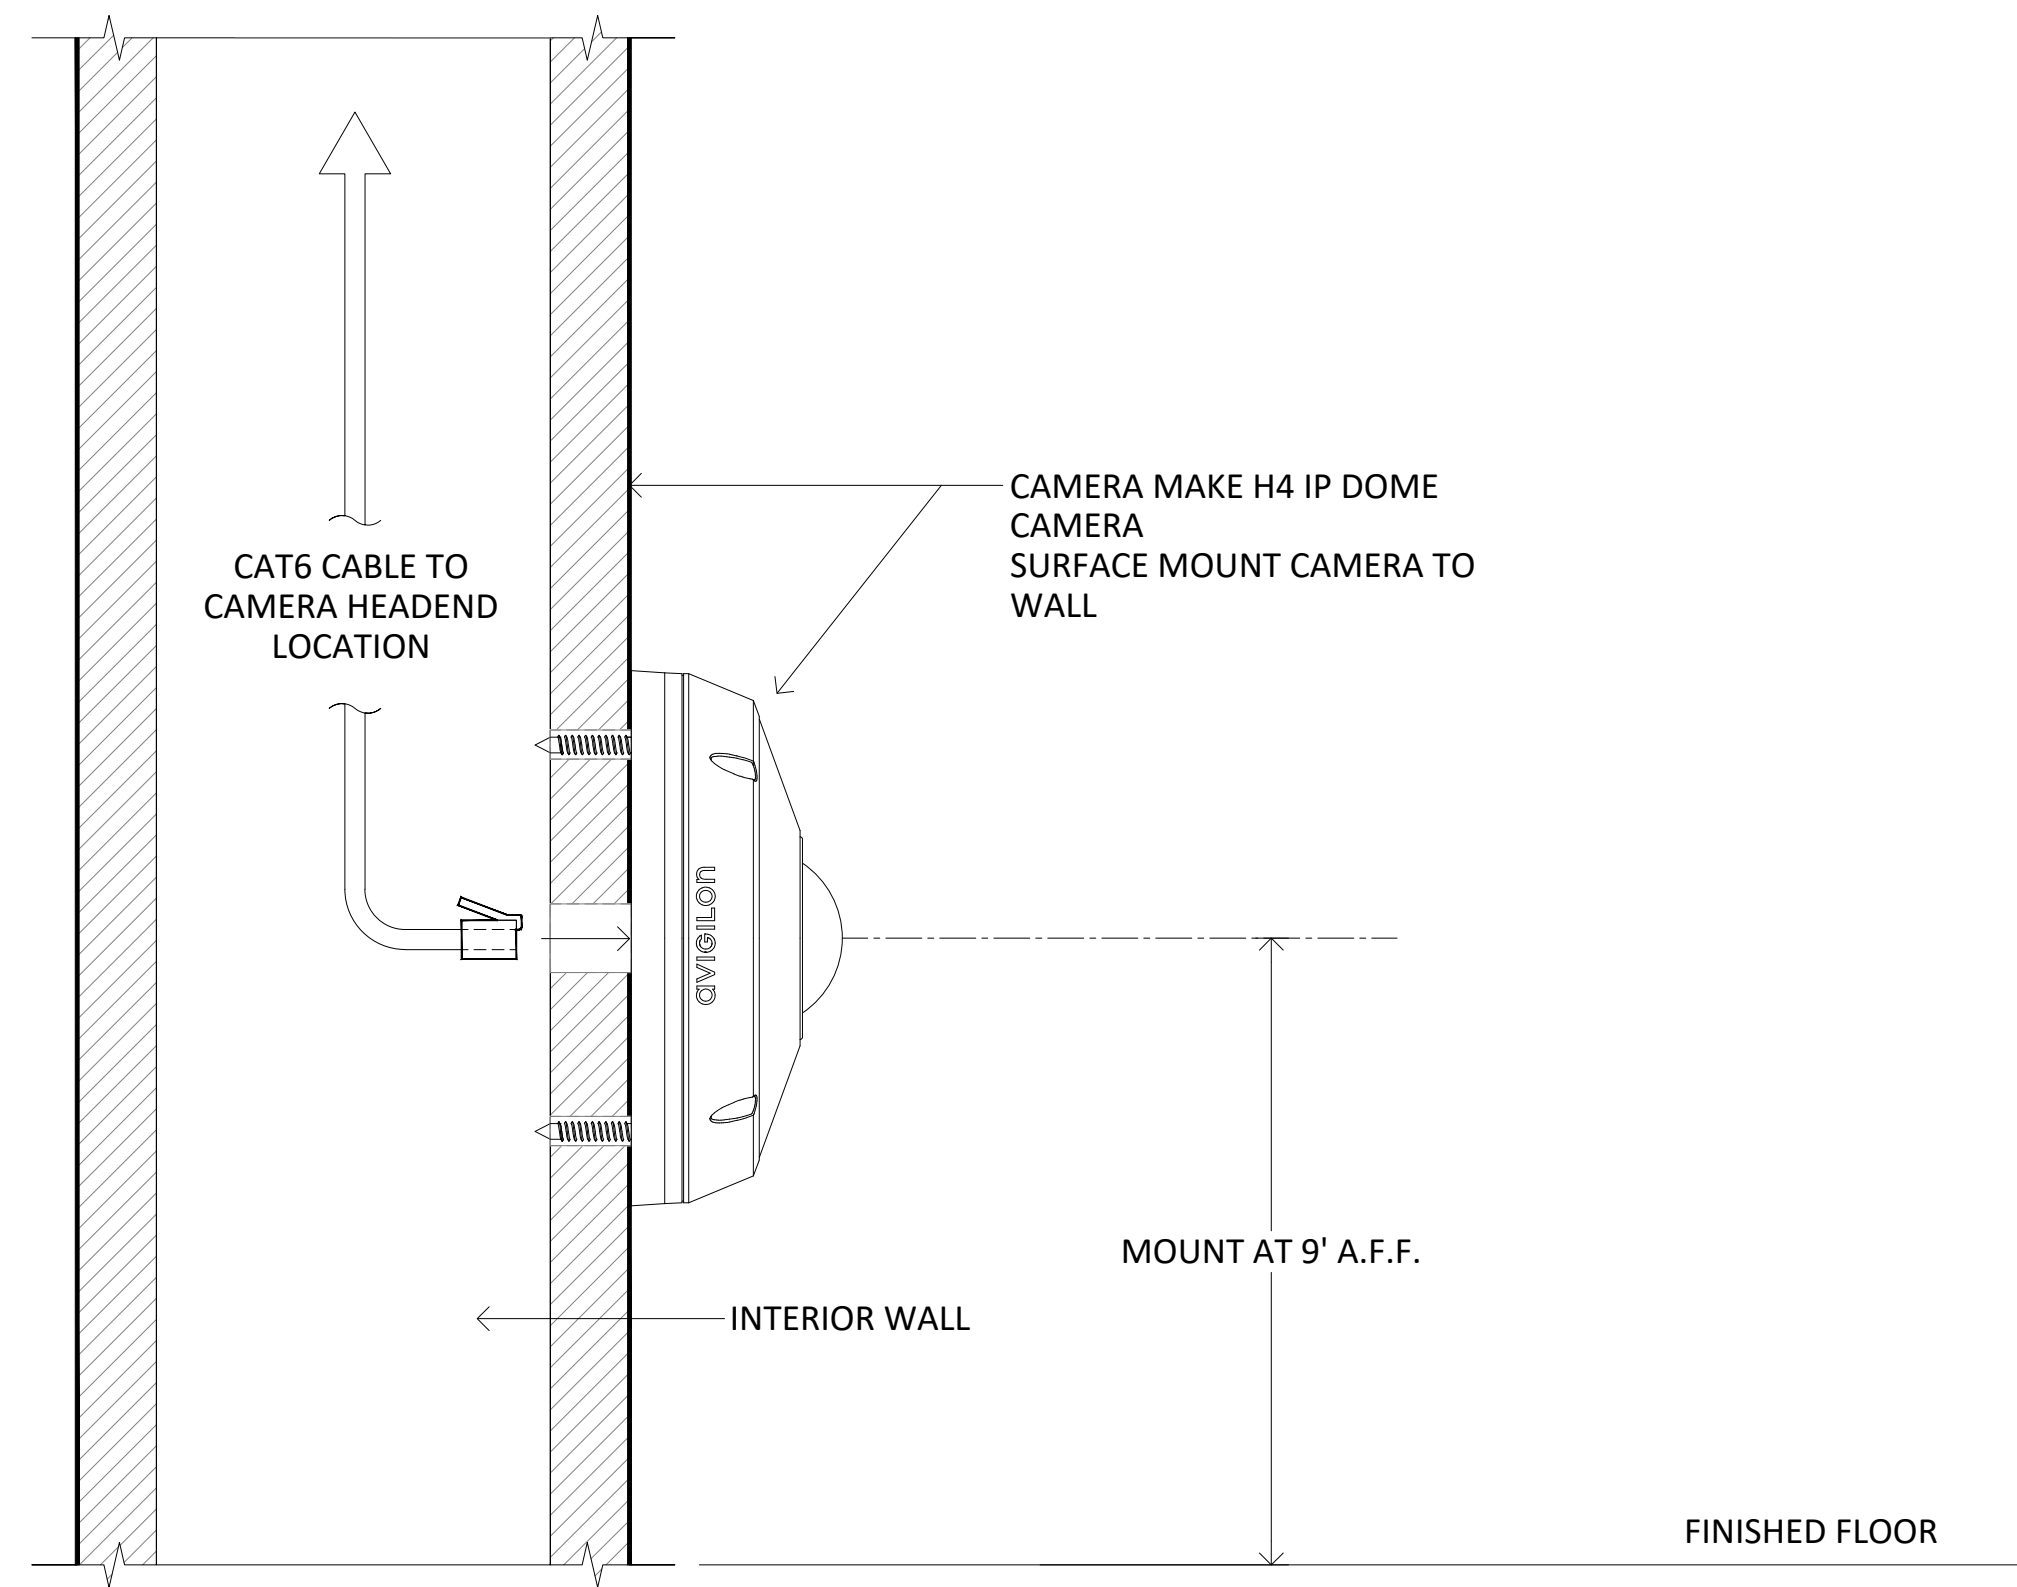

2 DETAIL - TYPICAL H4 DOME CAMERA SURFACE CEILING MOUNT
--- SCALE: T.S.

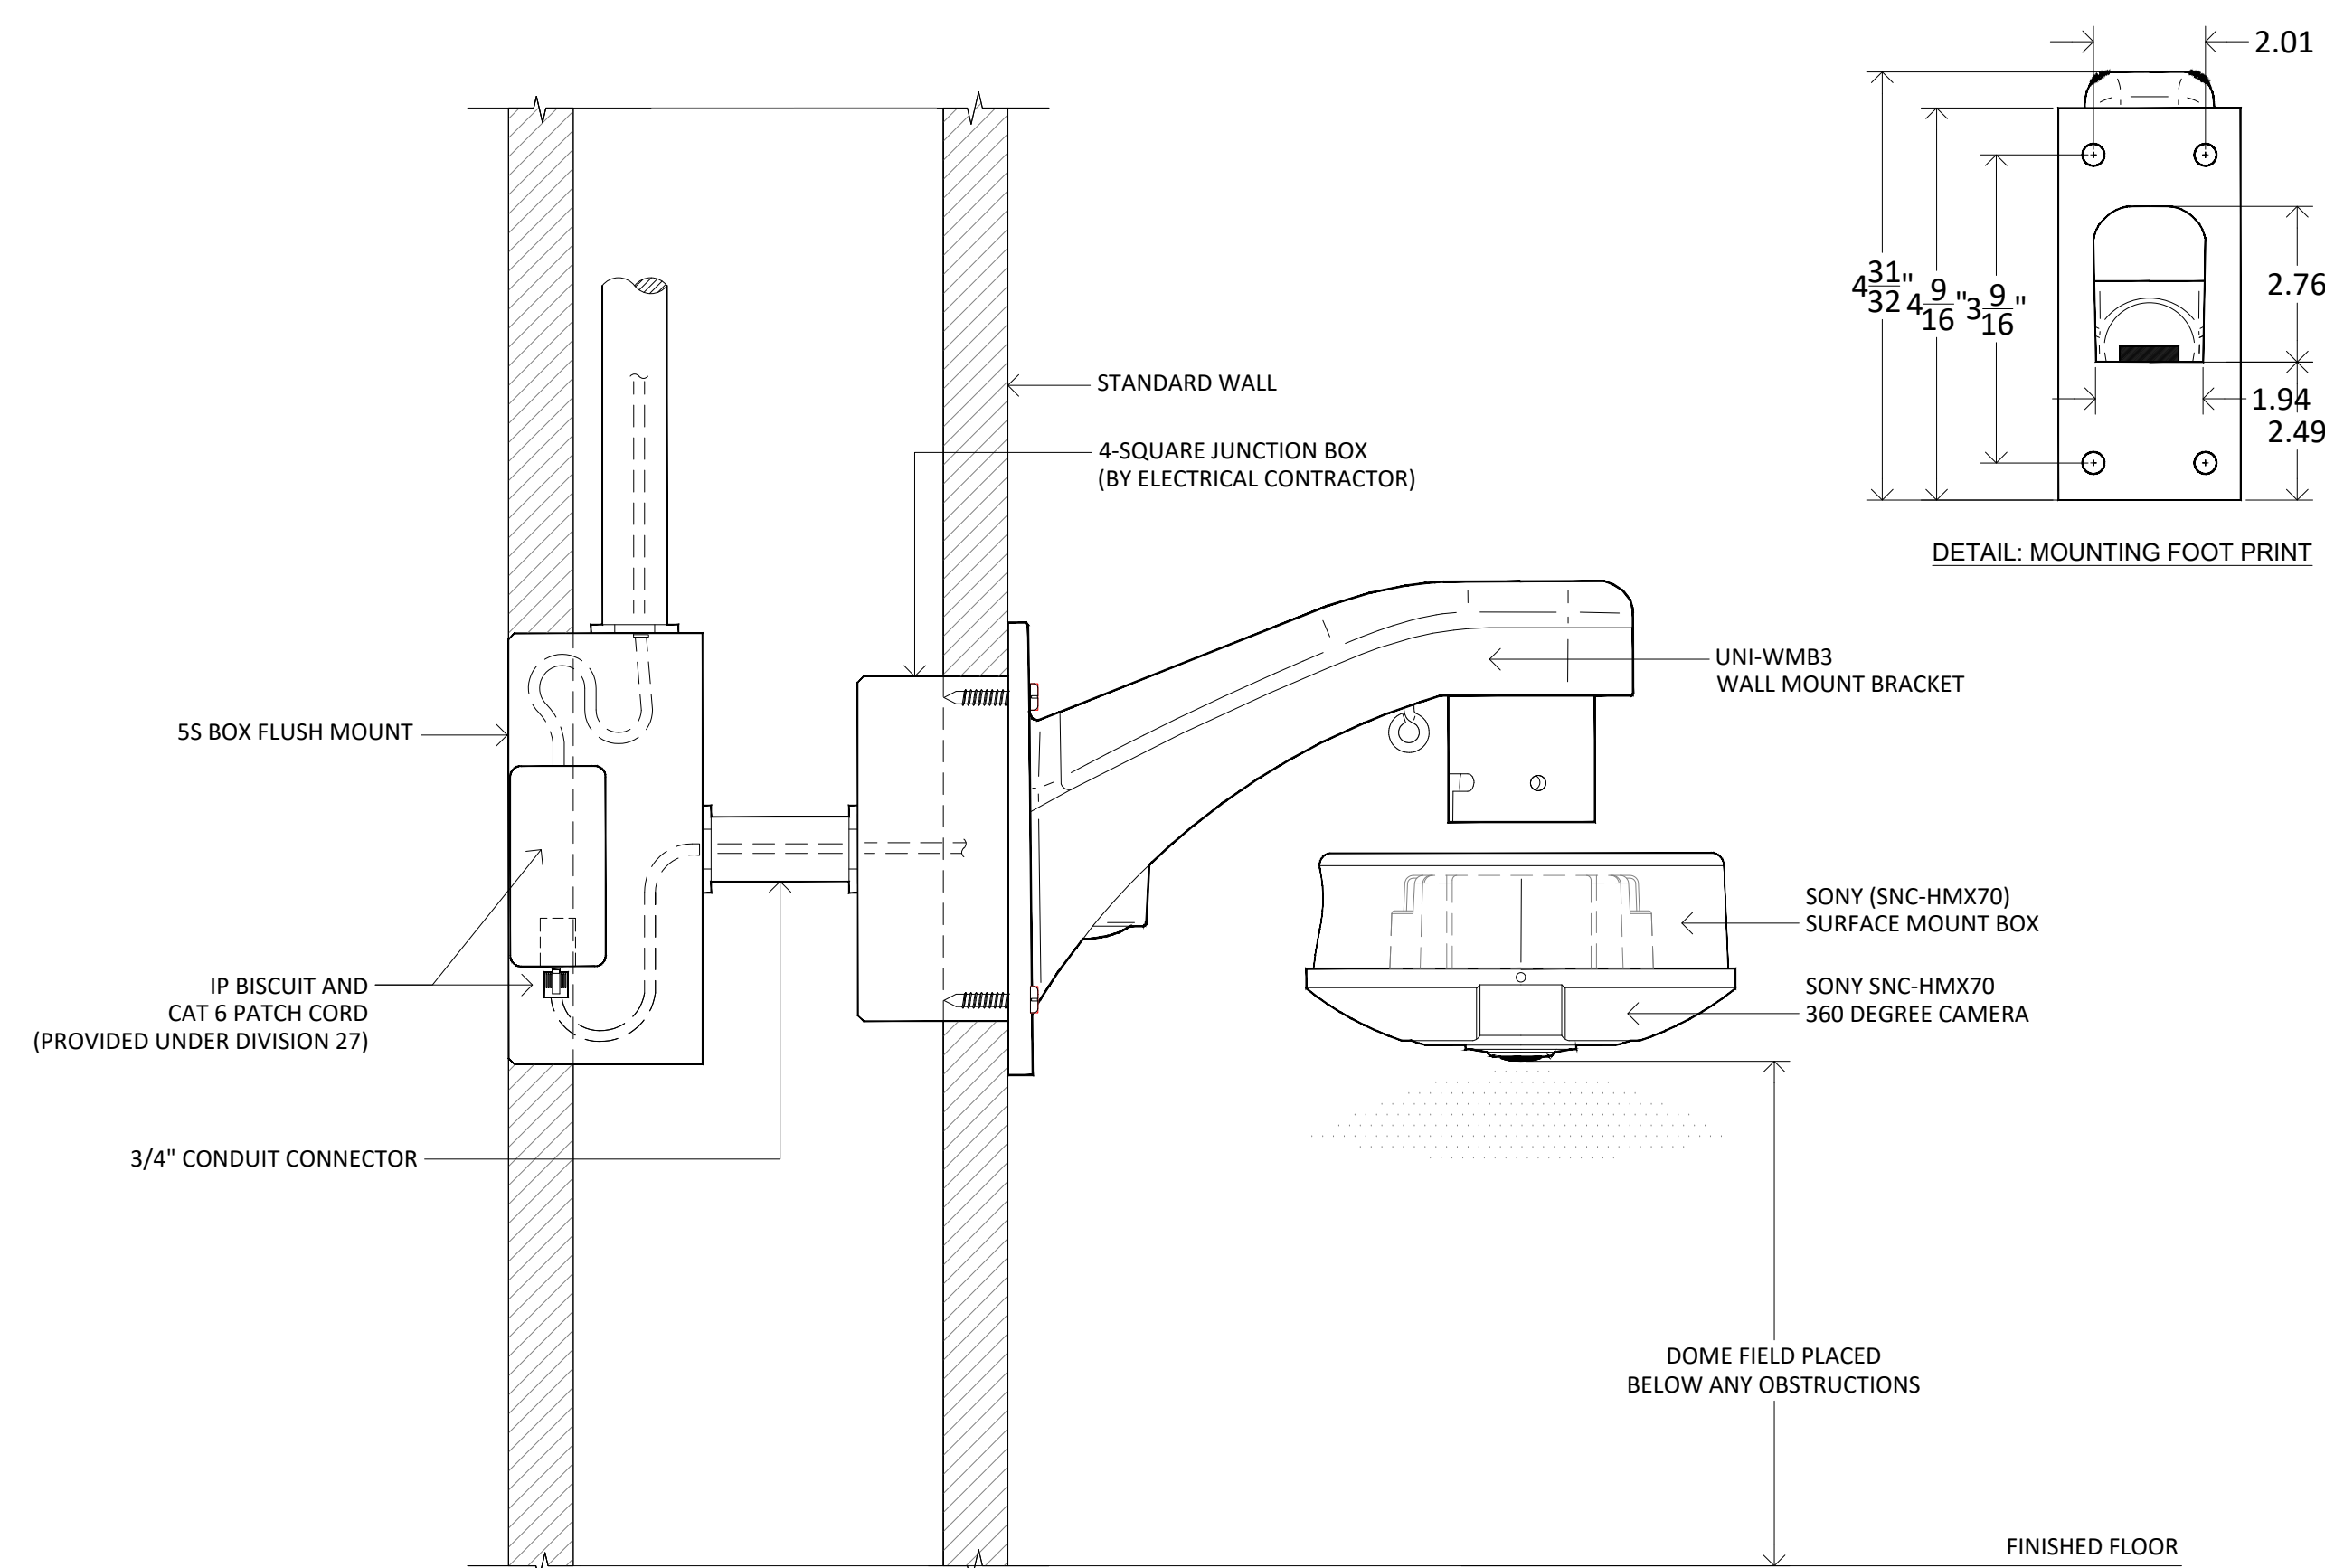

3 DETAIL: TYPICAL SONY 360 DOME CAMERA - PENDANT WALL MOUNT (UNI-WMB3) WITH A VIDEO BISCUIT
--- SCALE: T.S.

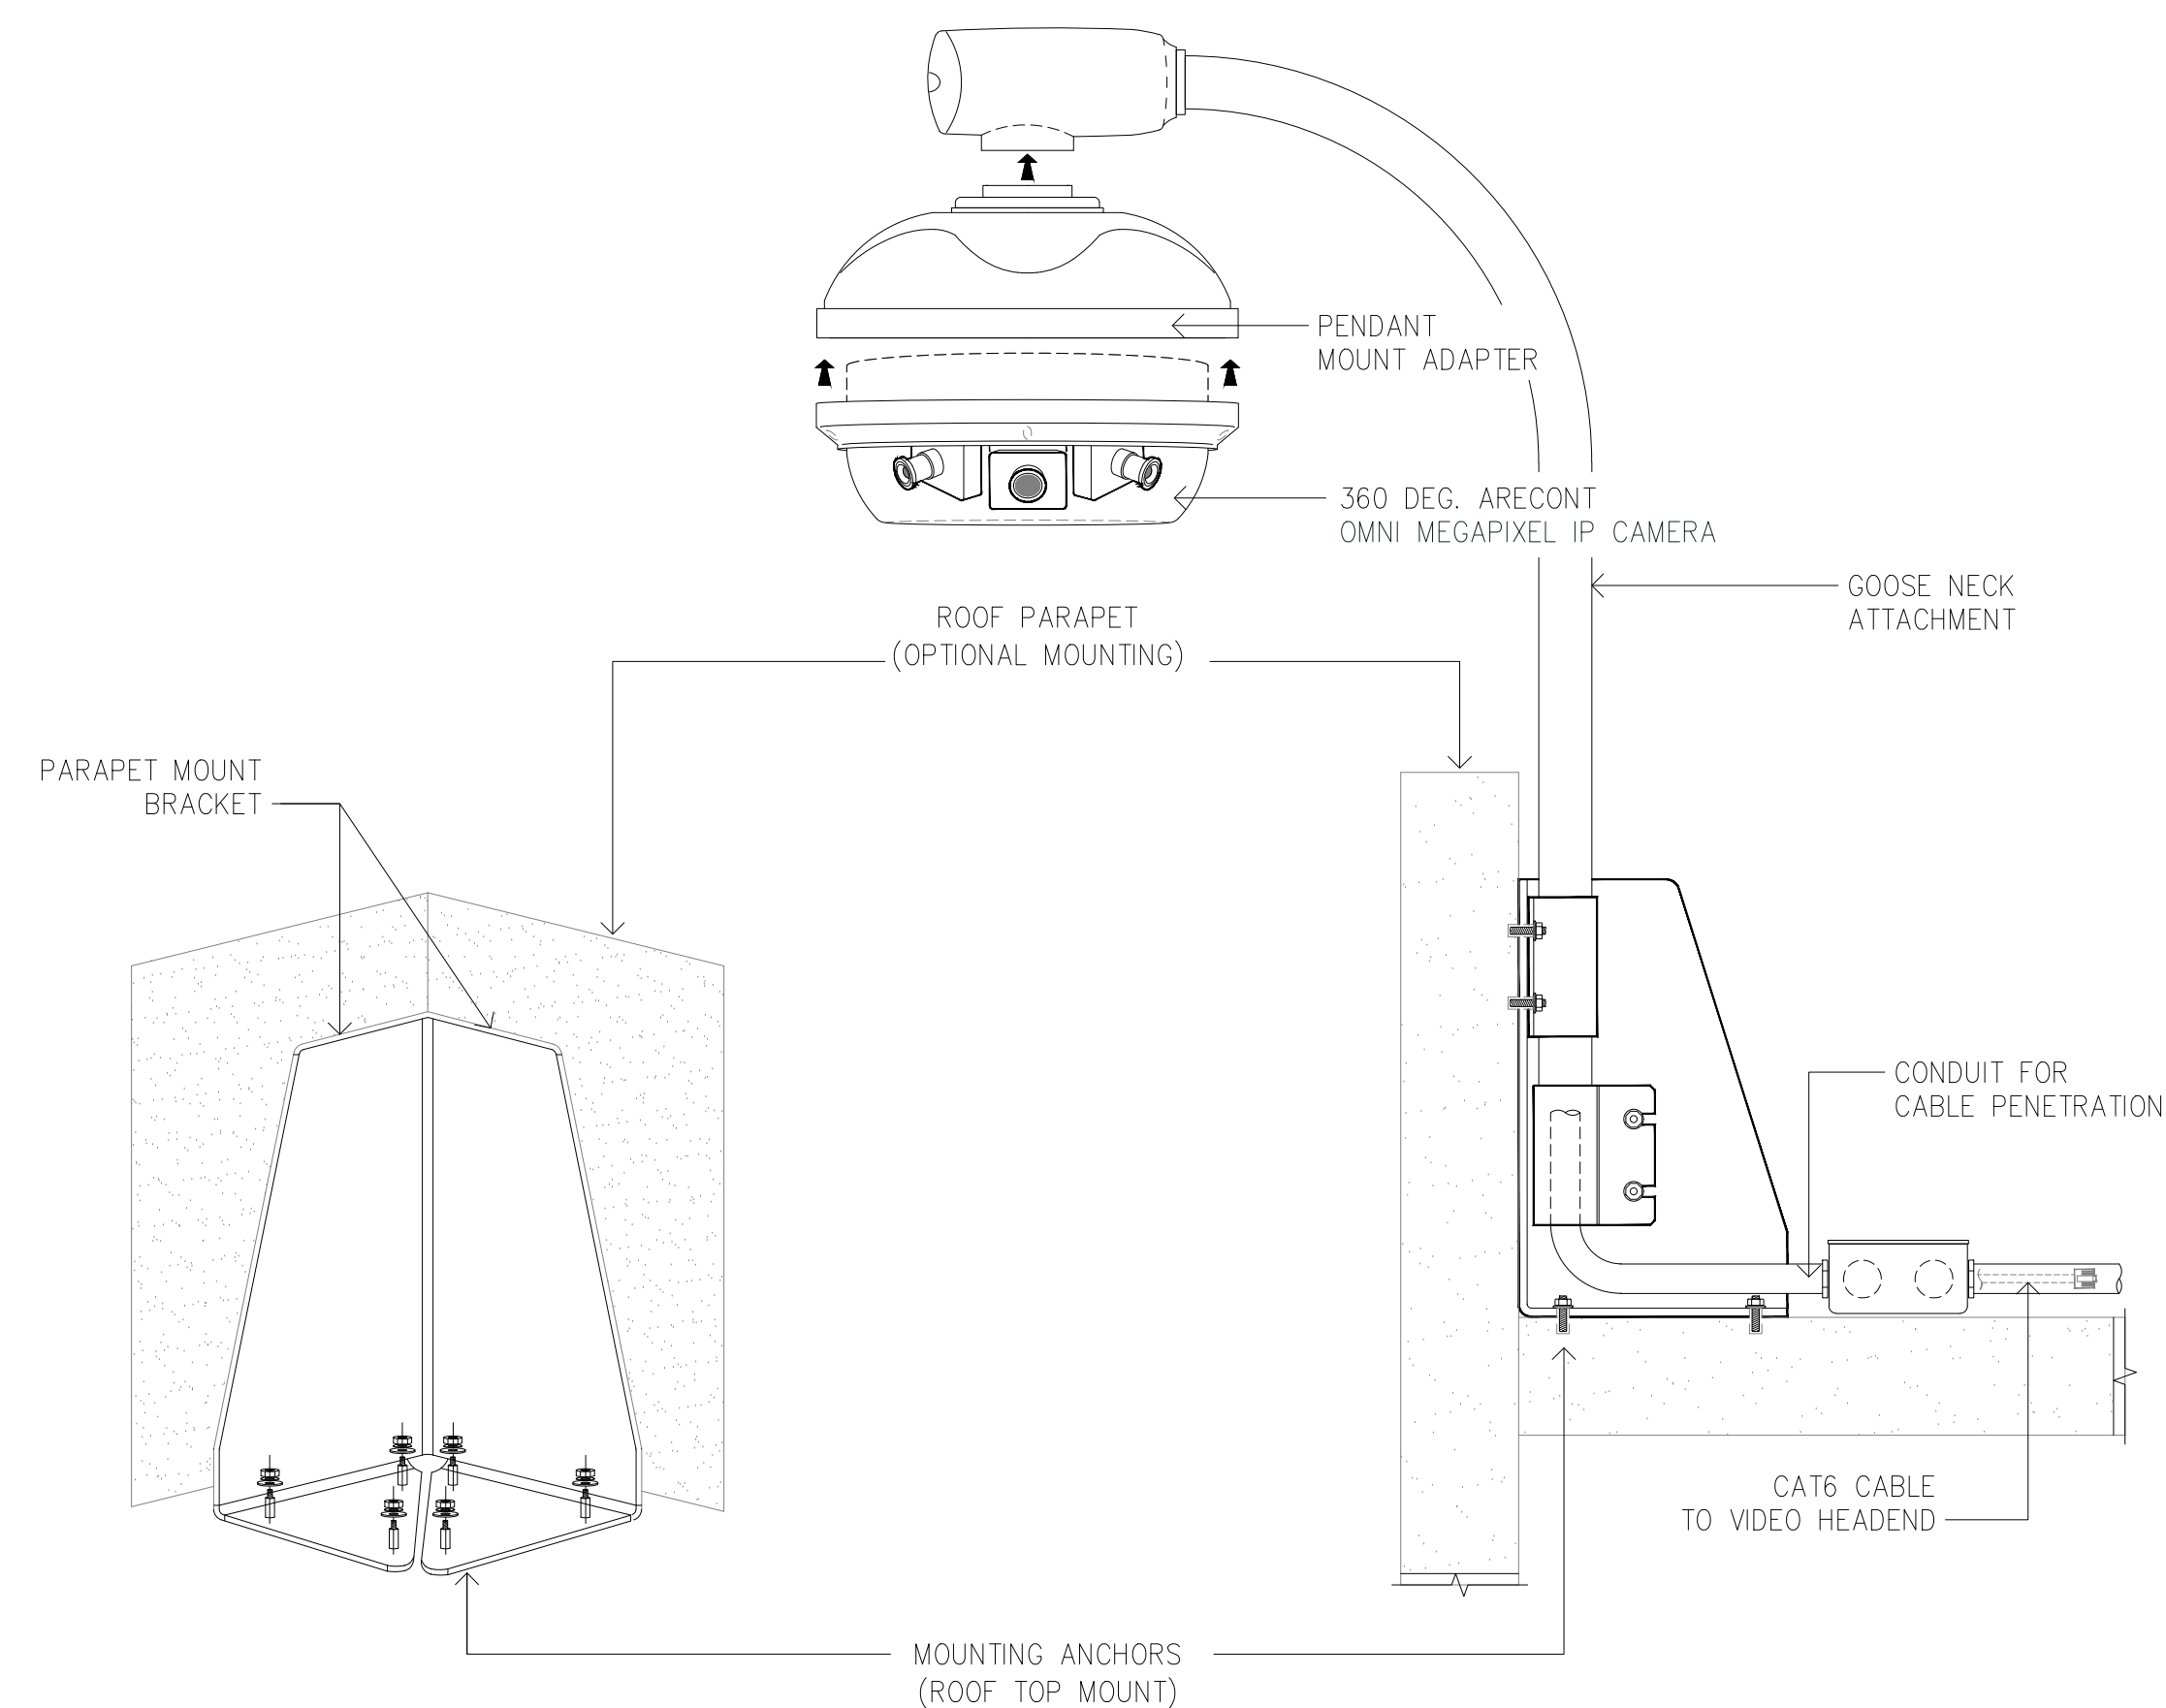

4 ARECONT- MEGAPIXEL 360 DEG IP CAMERA (PARAPET ROOF MOUNT)
--- SCALE: T.S.

NOTES
CONNECT CAMERA TO THE ARECONT
PENDANT MOUNT ADAPTER.
INSTALL CAMERA AND PENDANT MOUNT
ADAPTER TO THE GOOSE NECK PORTION OF
THE PENDANT MOUNT.
GOOSE NECK CAMERA & PENDANT MOUNT
IS SECURED TO THE ROOF THROUGH THE
PARAPET MOUNT BRACKET AND ANCHOR
BOLTS.

REV	DATE	DESCRIPTION

SECURITY GROUP NAME
STREET ADDRESS
CITY, STATE & ZIP

ACCESS CONTROL \ IP VIDEO SYSTEMS
SAMPLE SECURITY SUBMITTAL


SAMPLE SECURITY DRAWINGS
STREET ADDRESS
CITY, STATE & ZIP

JOB NO.:
DRAWN: S.ESTES
ENG/CKD:
DATE:
SCALE: 1/8"=1'-0"


SHEET TITLE:
TYPICAL
CAMERA MOUNT
DETAILS

SHEET NUMBER:


ES2.1

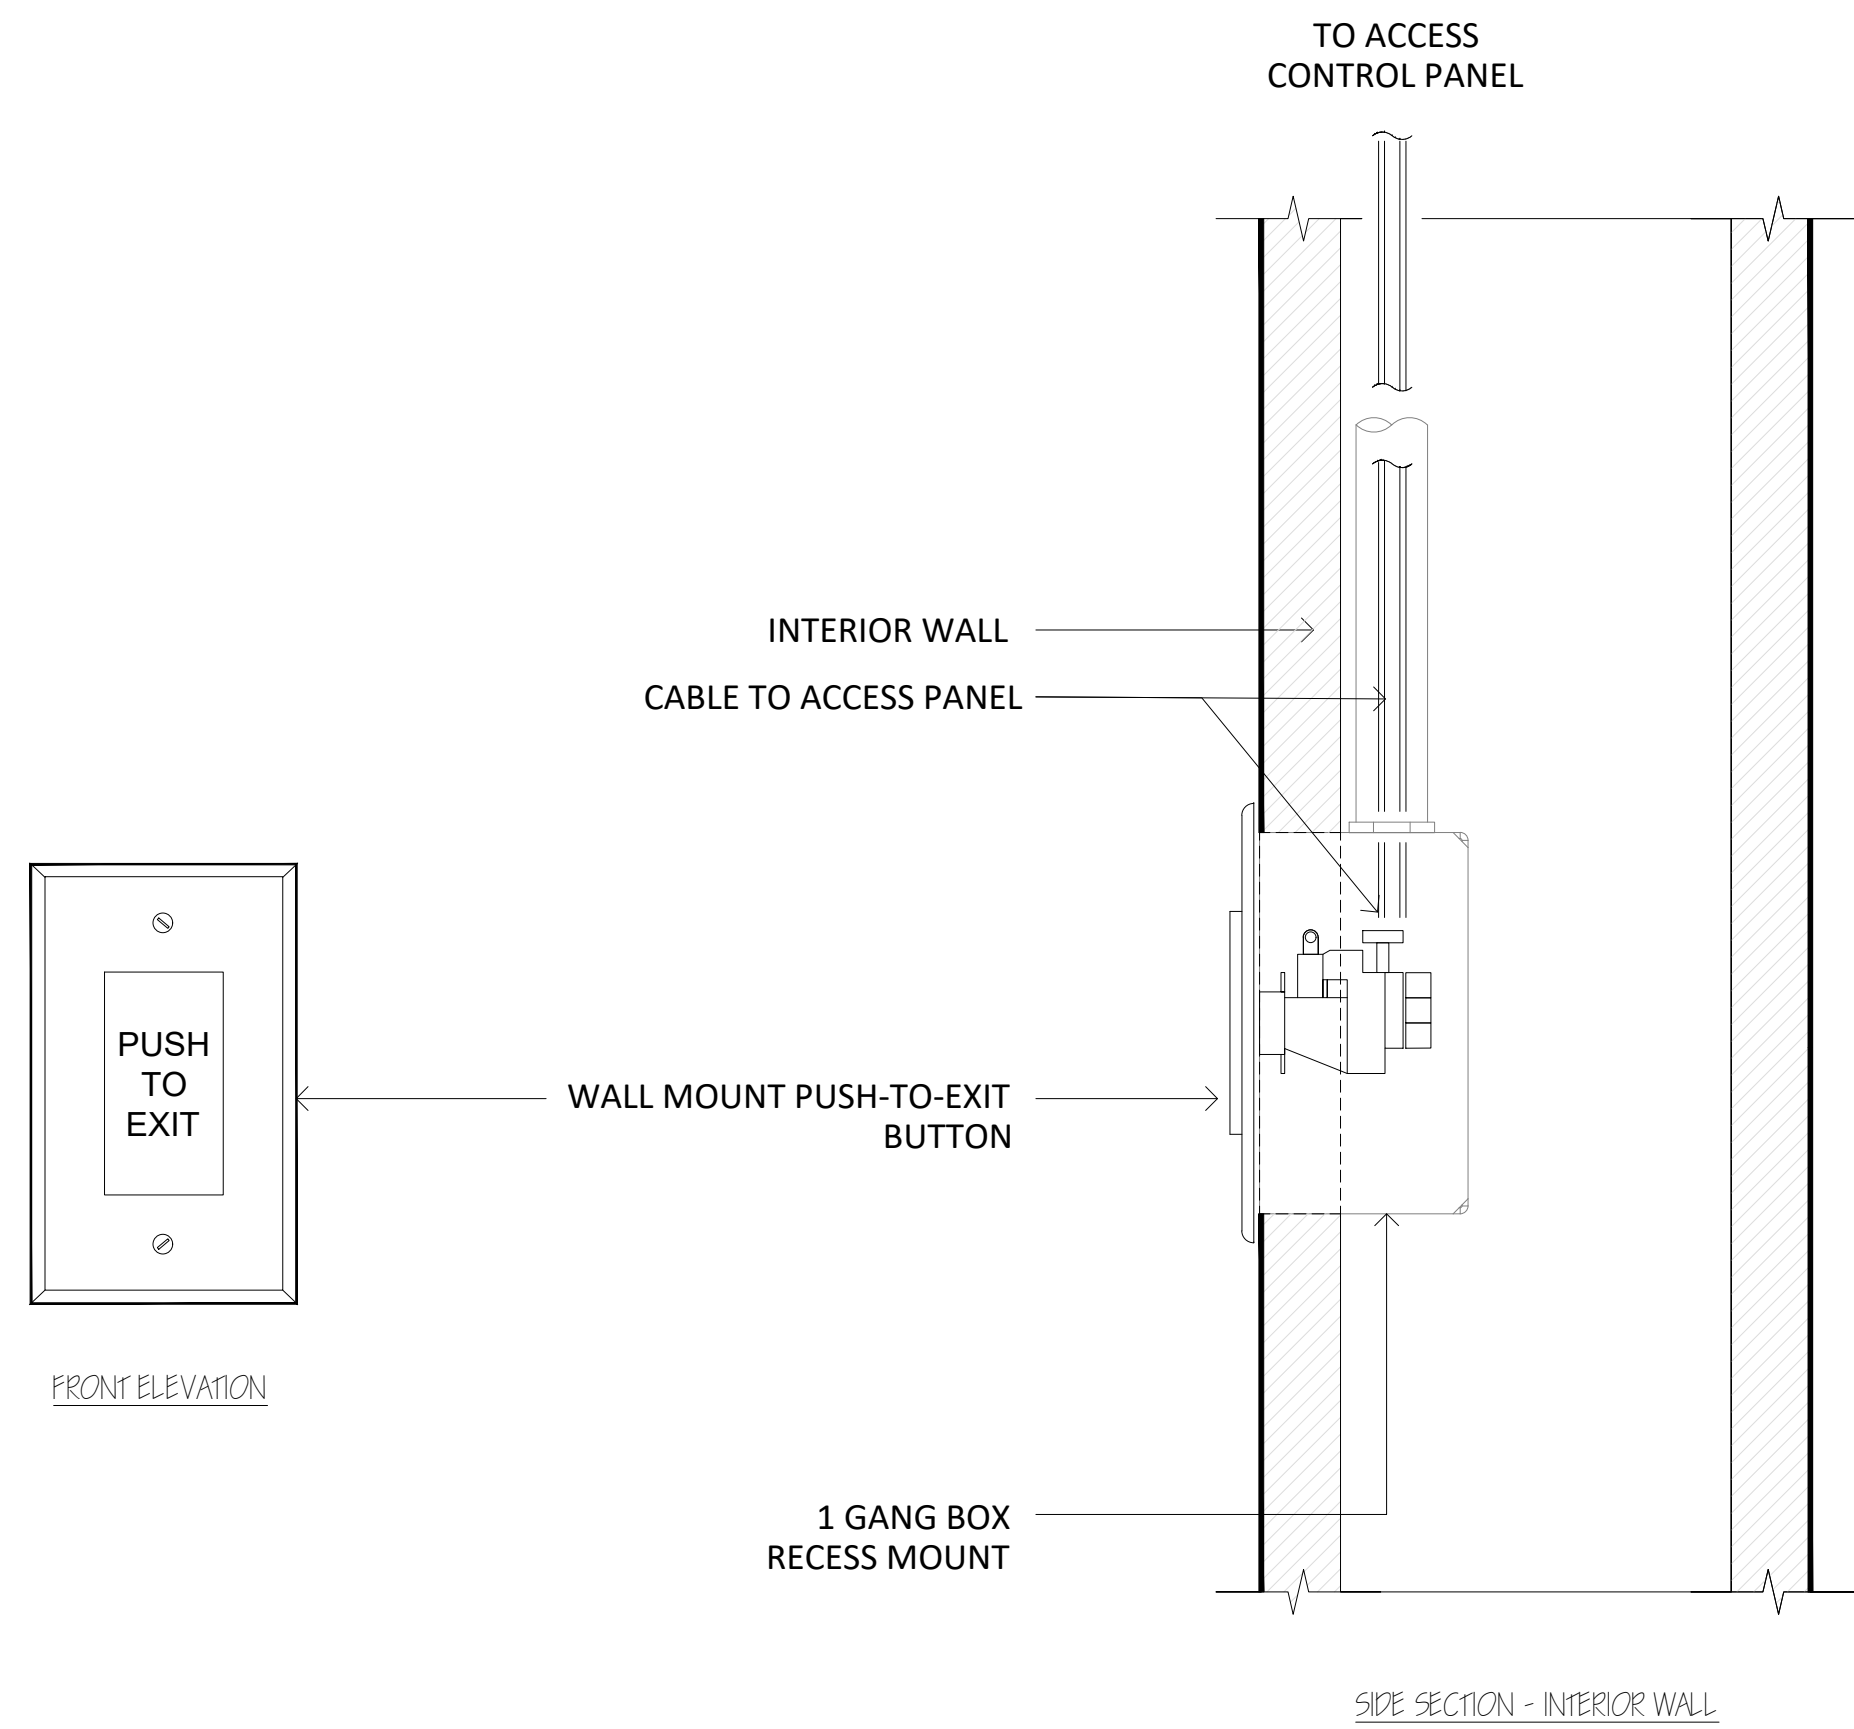




1 PUSH-TO-EXIT BUTTON DETAIL
SCALE: NTS

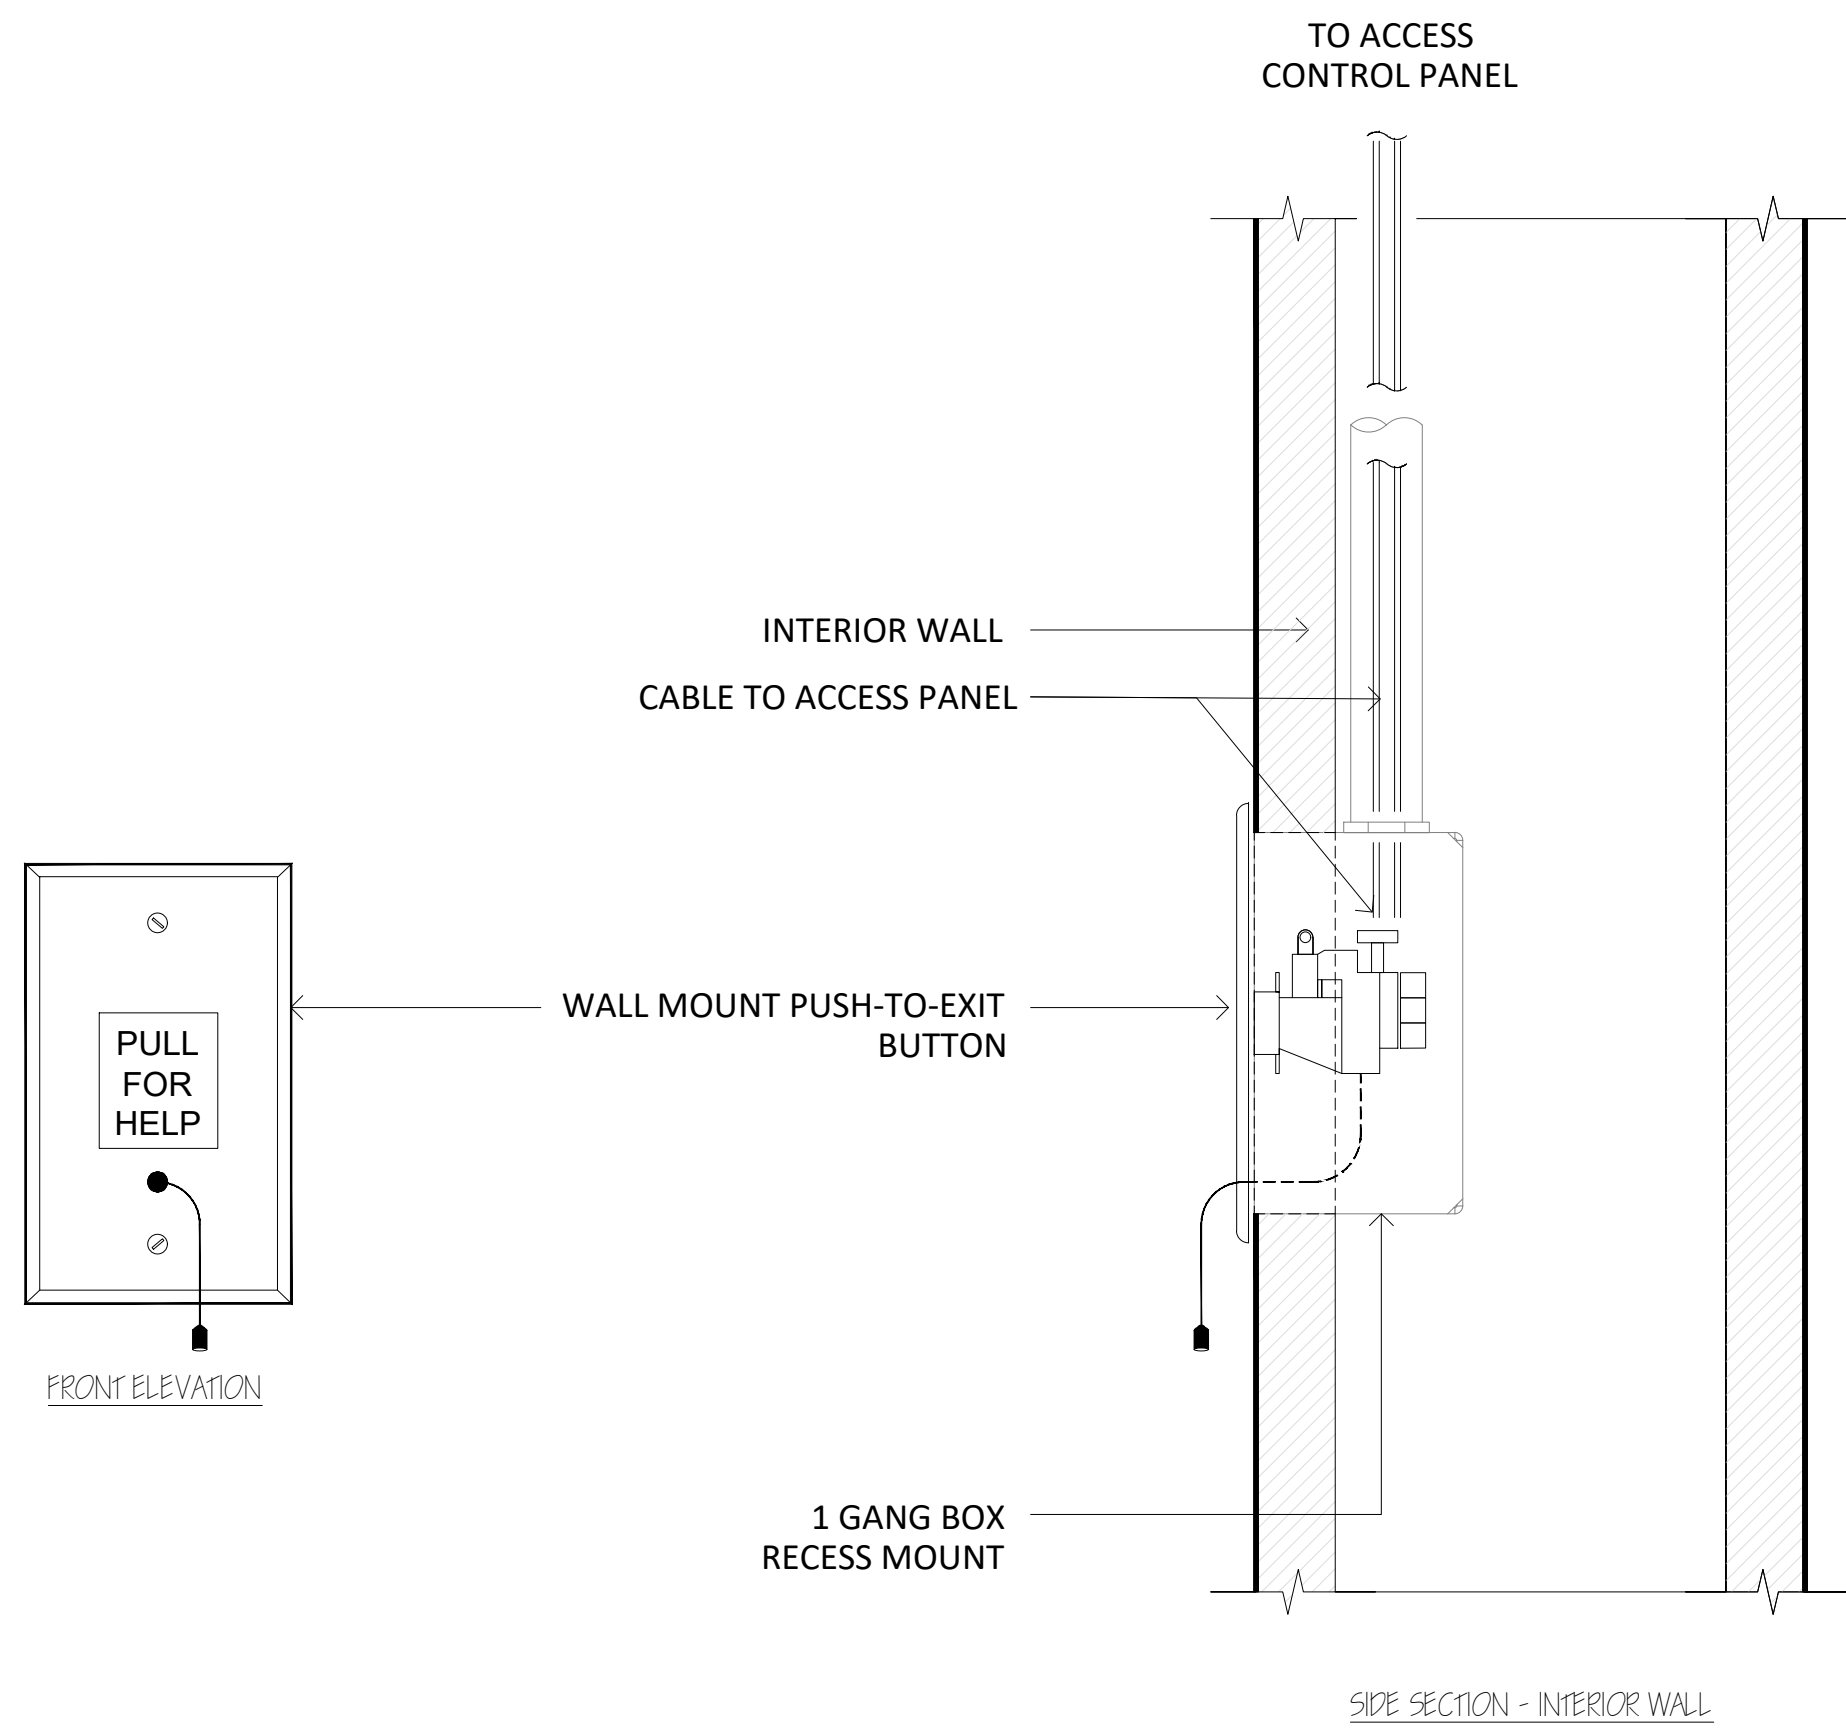

2 MOTHERS ROOM PULL-FOR-HELP SWITCH
SCALE: NTS

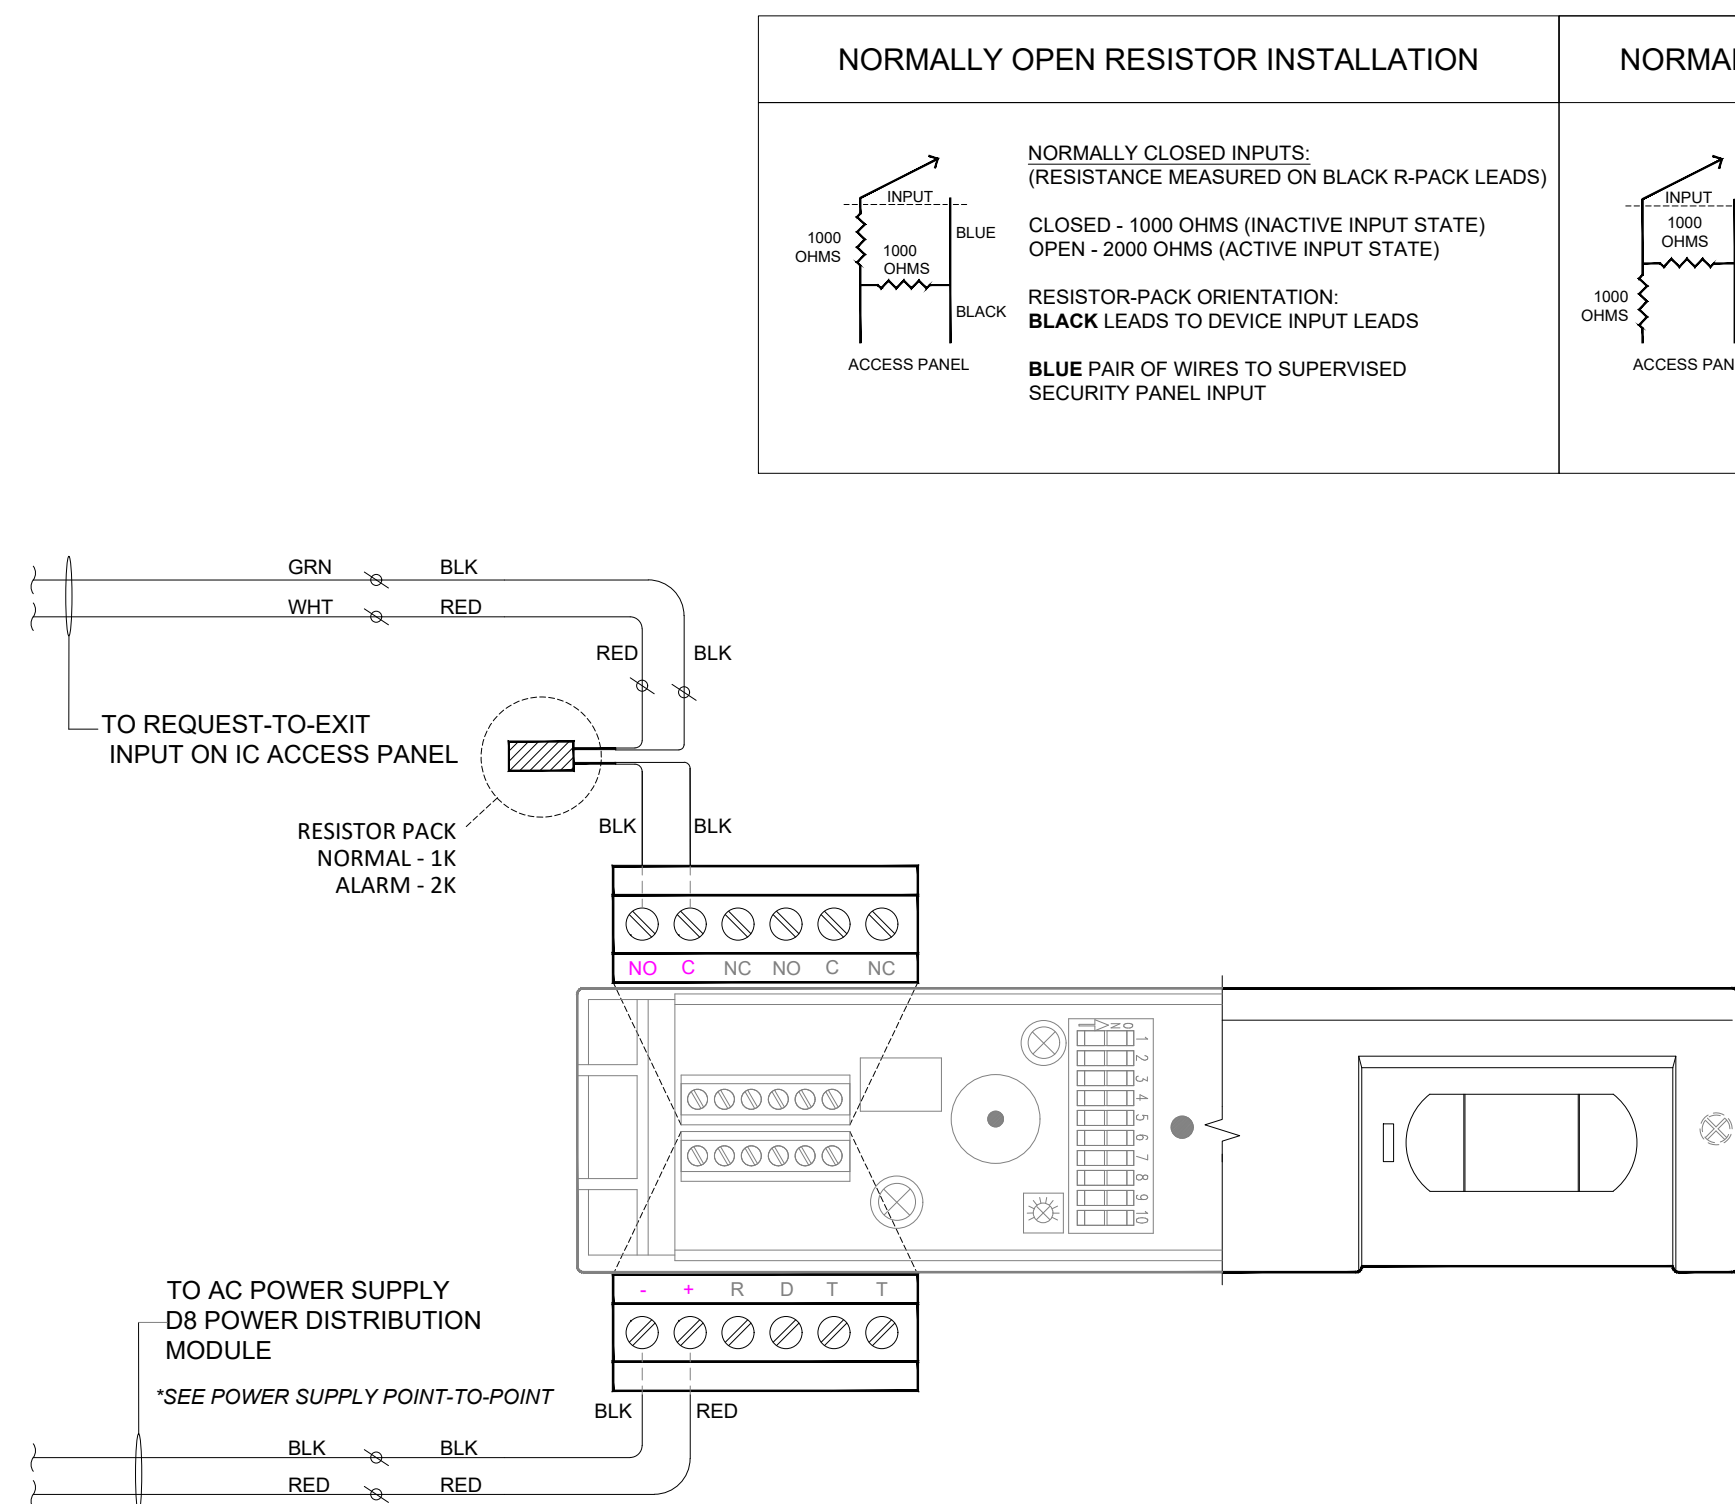

3 REQUEST-TO-EXIT MOTION SENSOR
SCALE: NTS

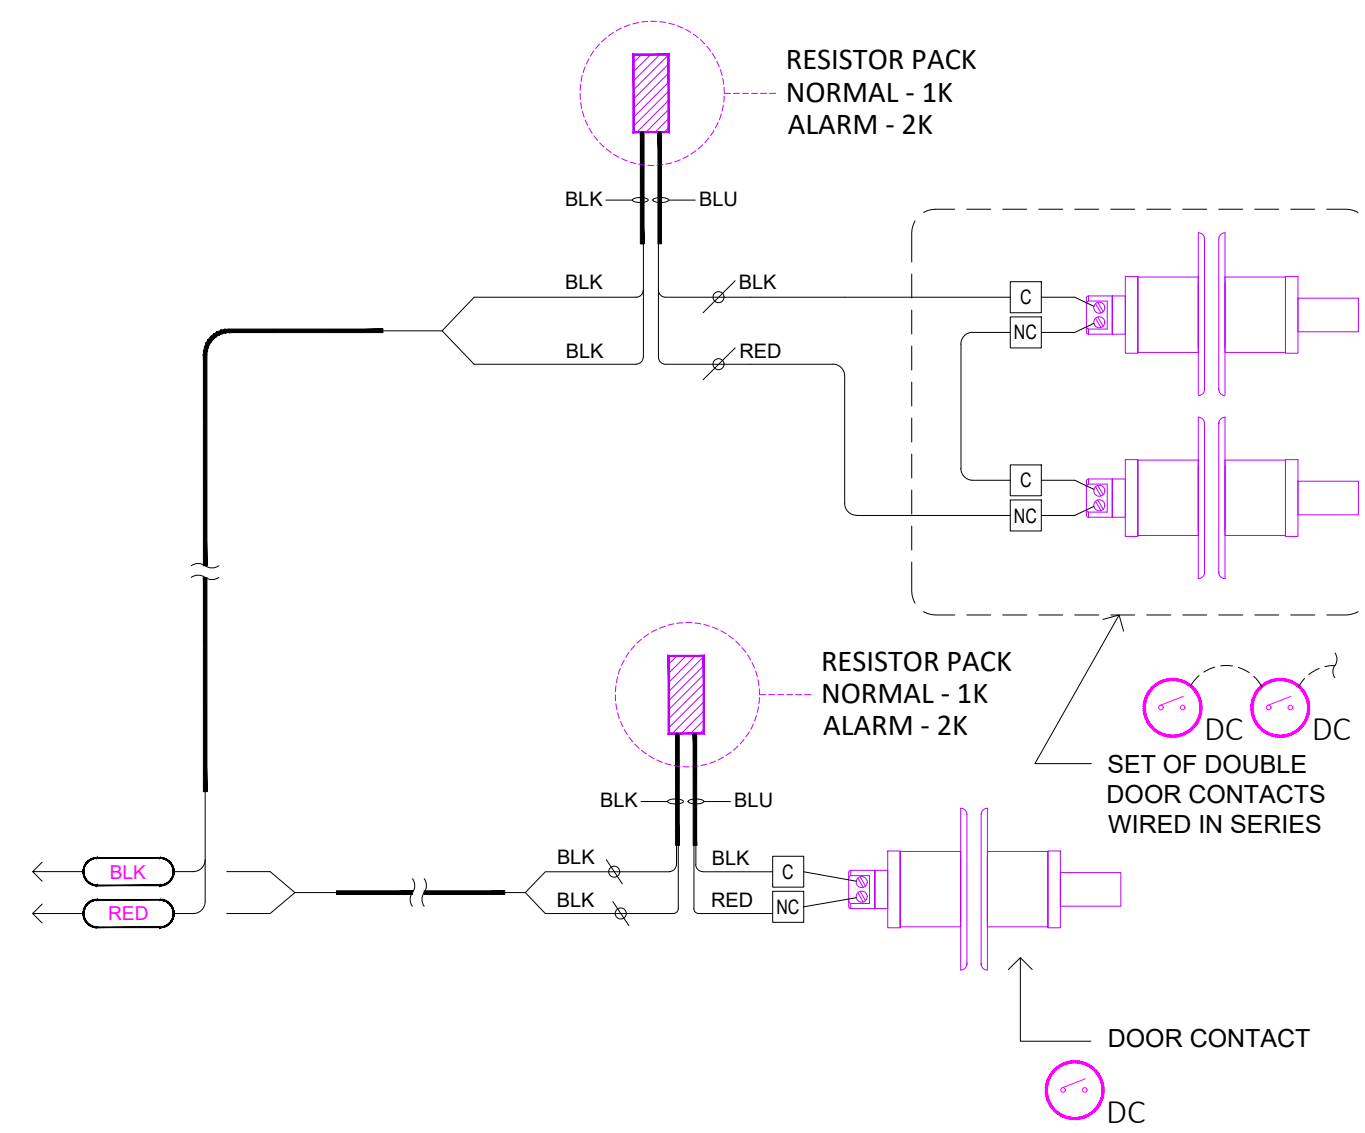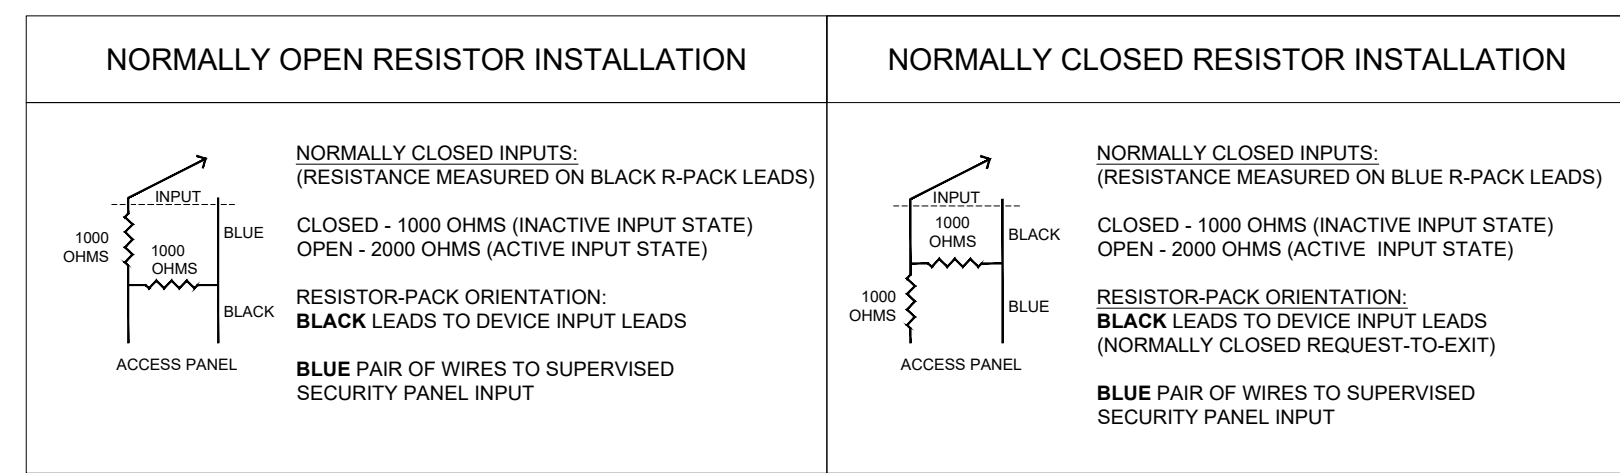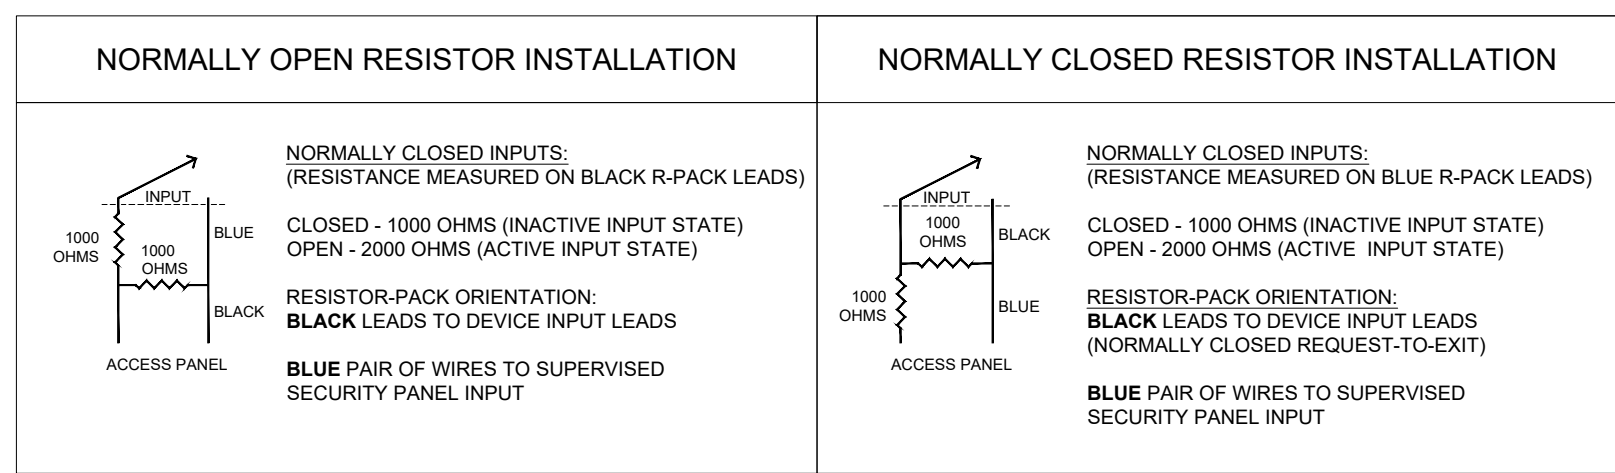

4 DOOR CONTACT DETAIL
SCALE: NTS

REV	DATE	DESCRIPTION

SECURITY GROUP NAME
STREET ADDRESS
CITY, STATE & ZIP

ACCESS CONTROL / IP VIDEO SYSTEMS
SAMPLE SECURITY SUBMITTAL


SAMPLE SECURITY DRAWINGS
STREET ADDRESS
CITY, STATE & ZIP

JOB NO.:
DRAWN: S.ESTES
ENG/CKD:
DATE:
SCALE: 1/8"=1'-0"


SHEET TITLE:
ACCESS CONTROL COMPONENT DETAILS

SHEET NUMBER:


ES2.2

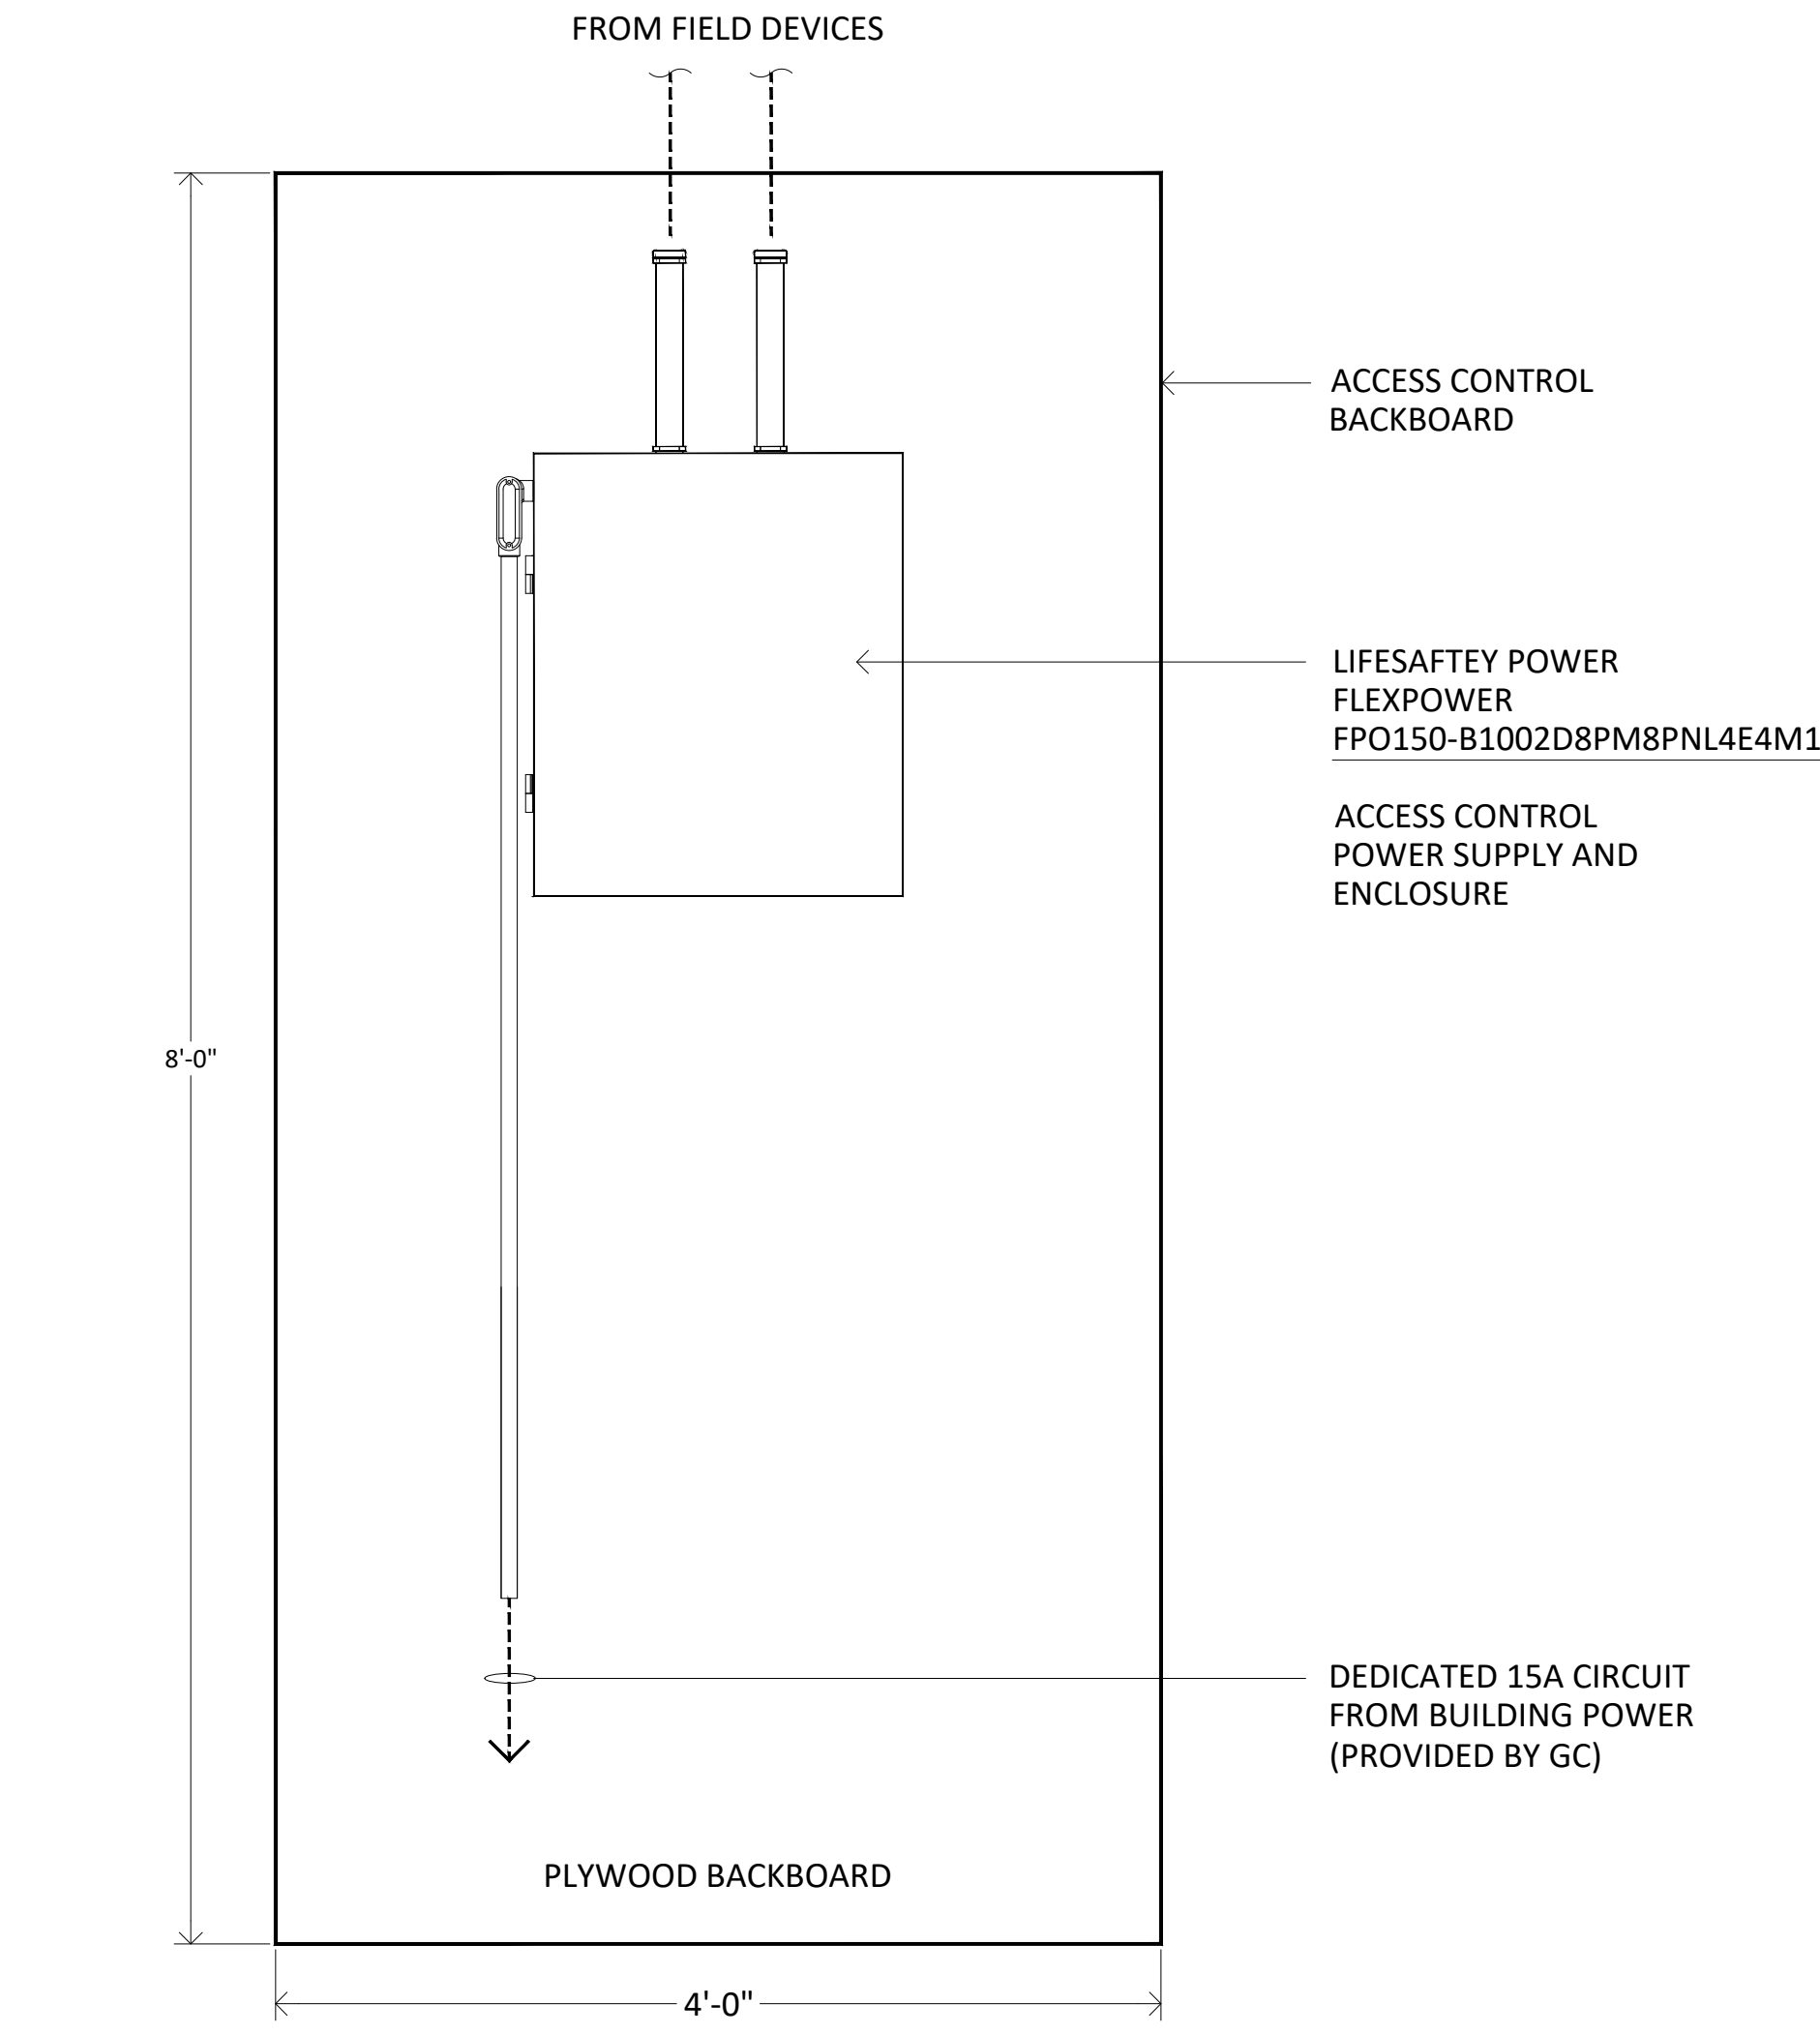

1 ACCESS CONTROL HEADEND ELEVATION
SCALE: NTS

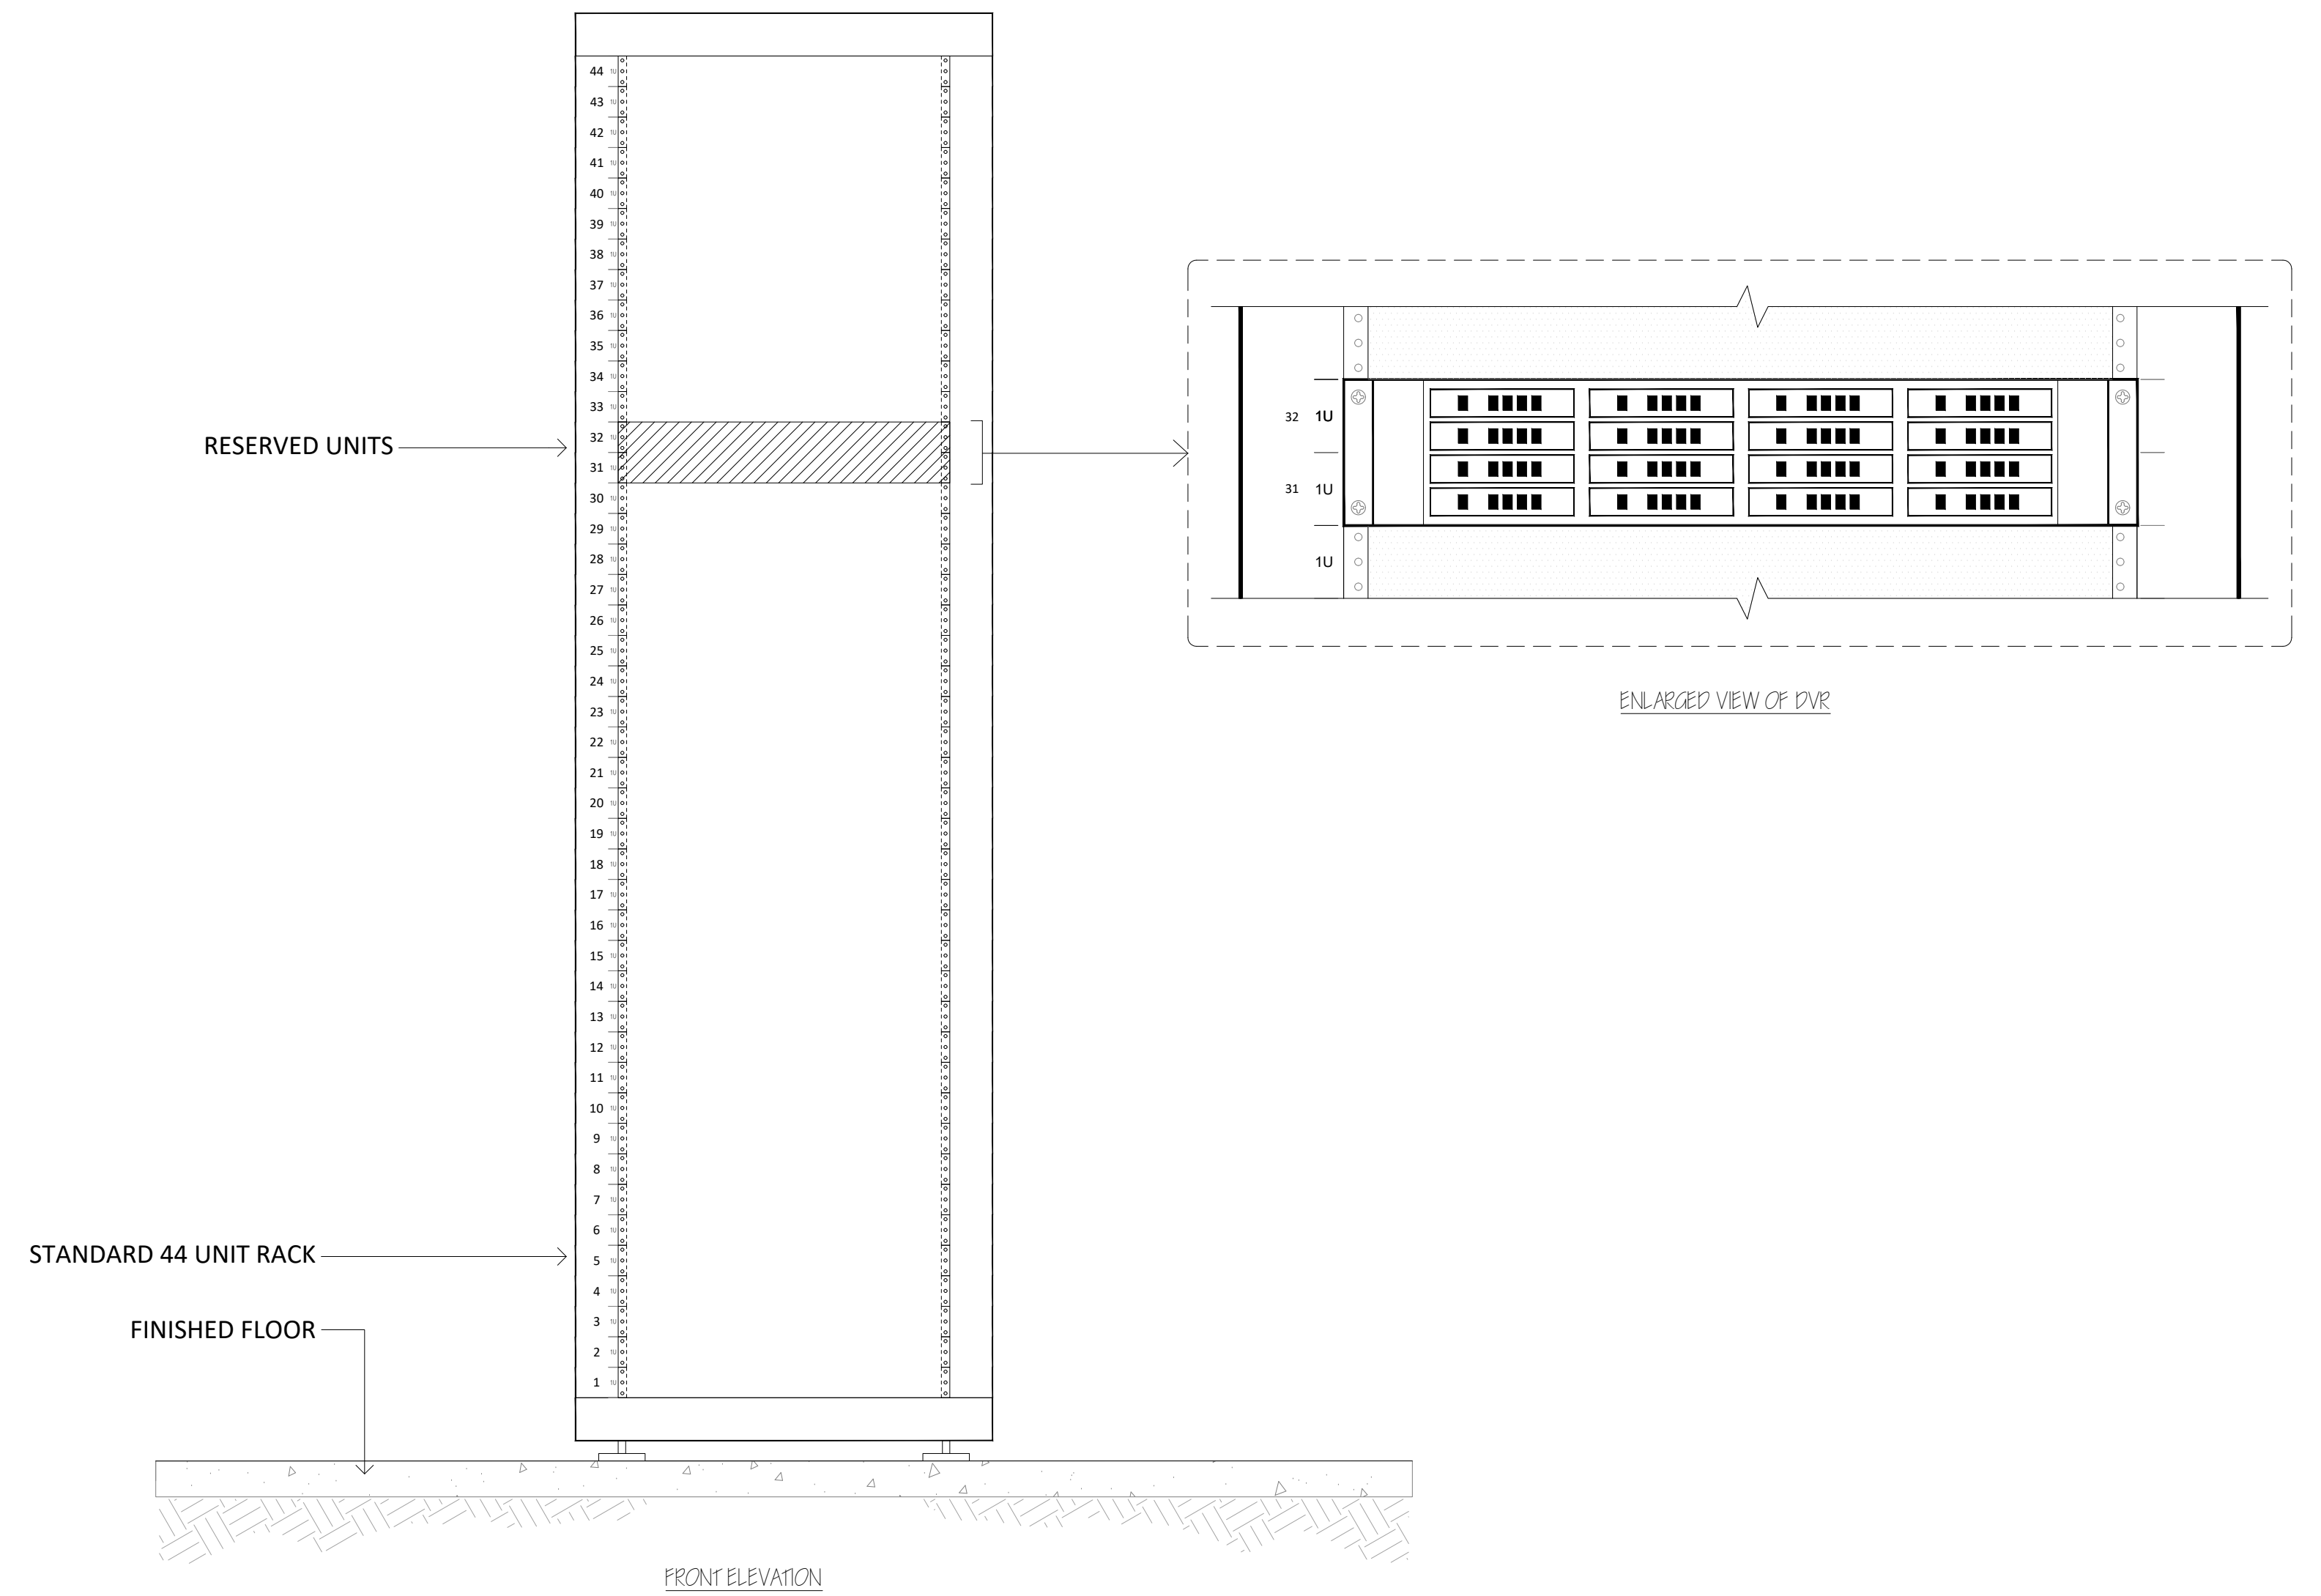

2 VIDEO RACK MOUNT SERVER (2U) FRONT ELEVATION DETAIL
SCALE: NTS

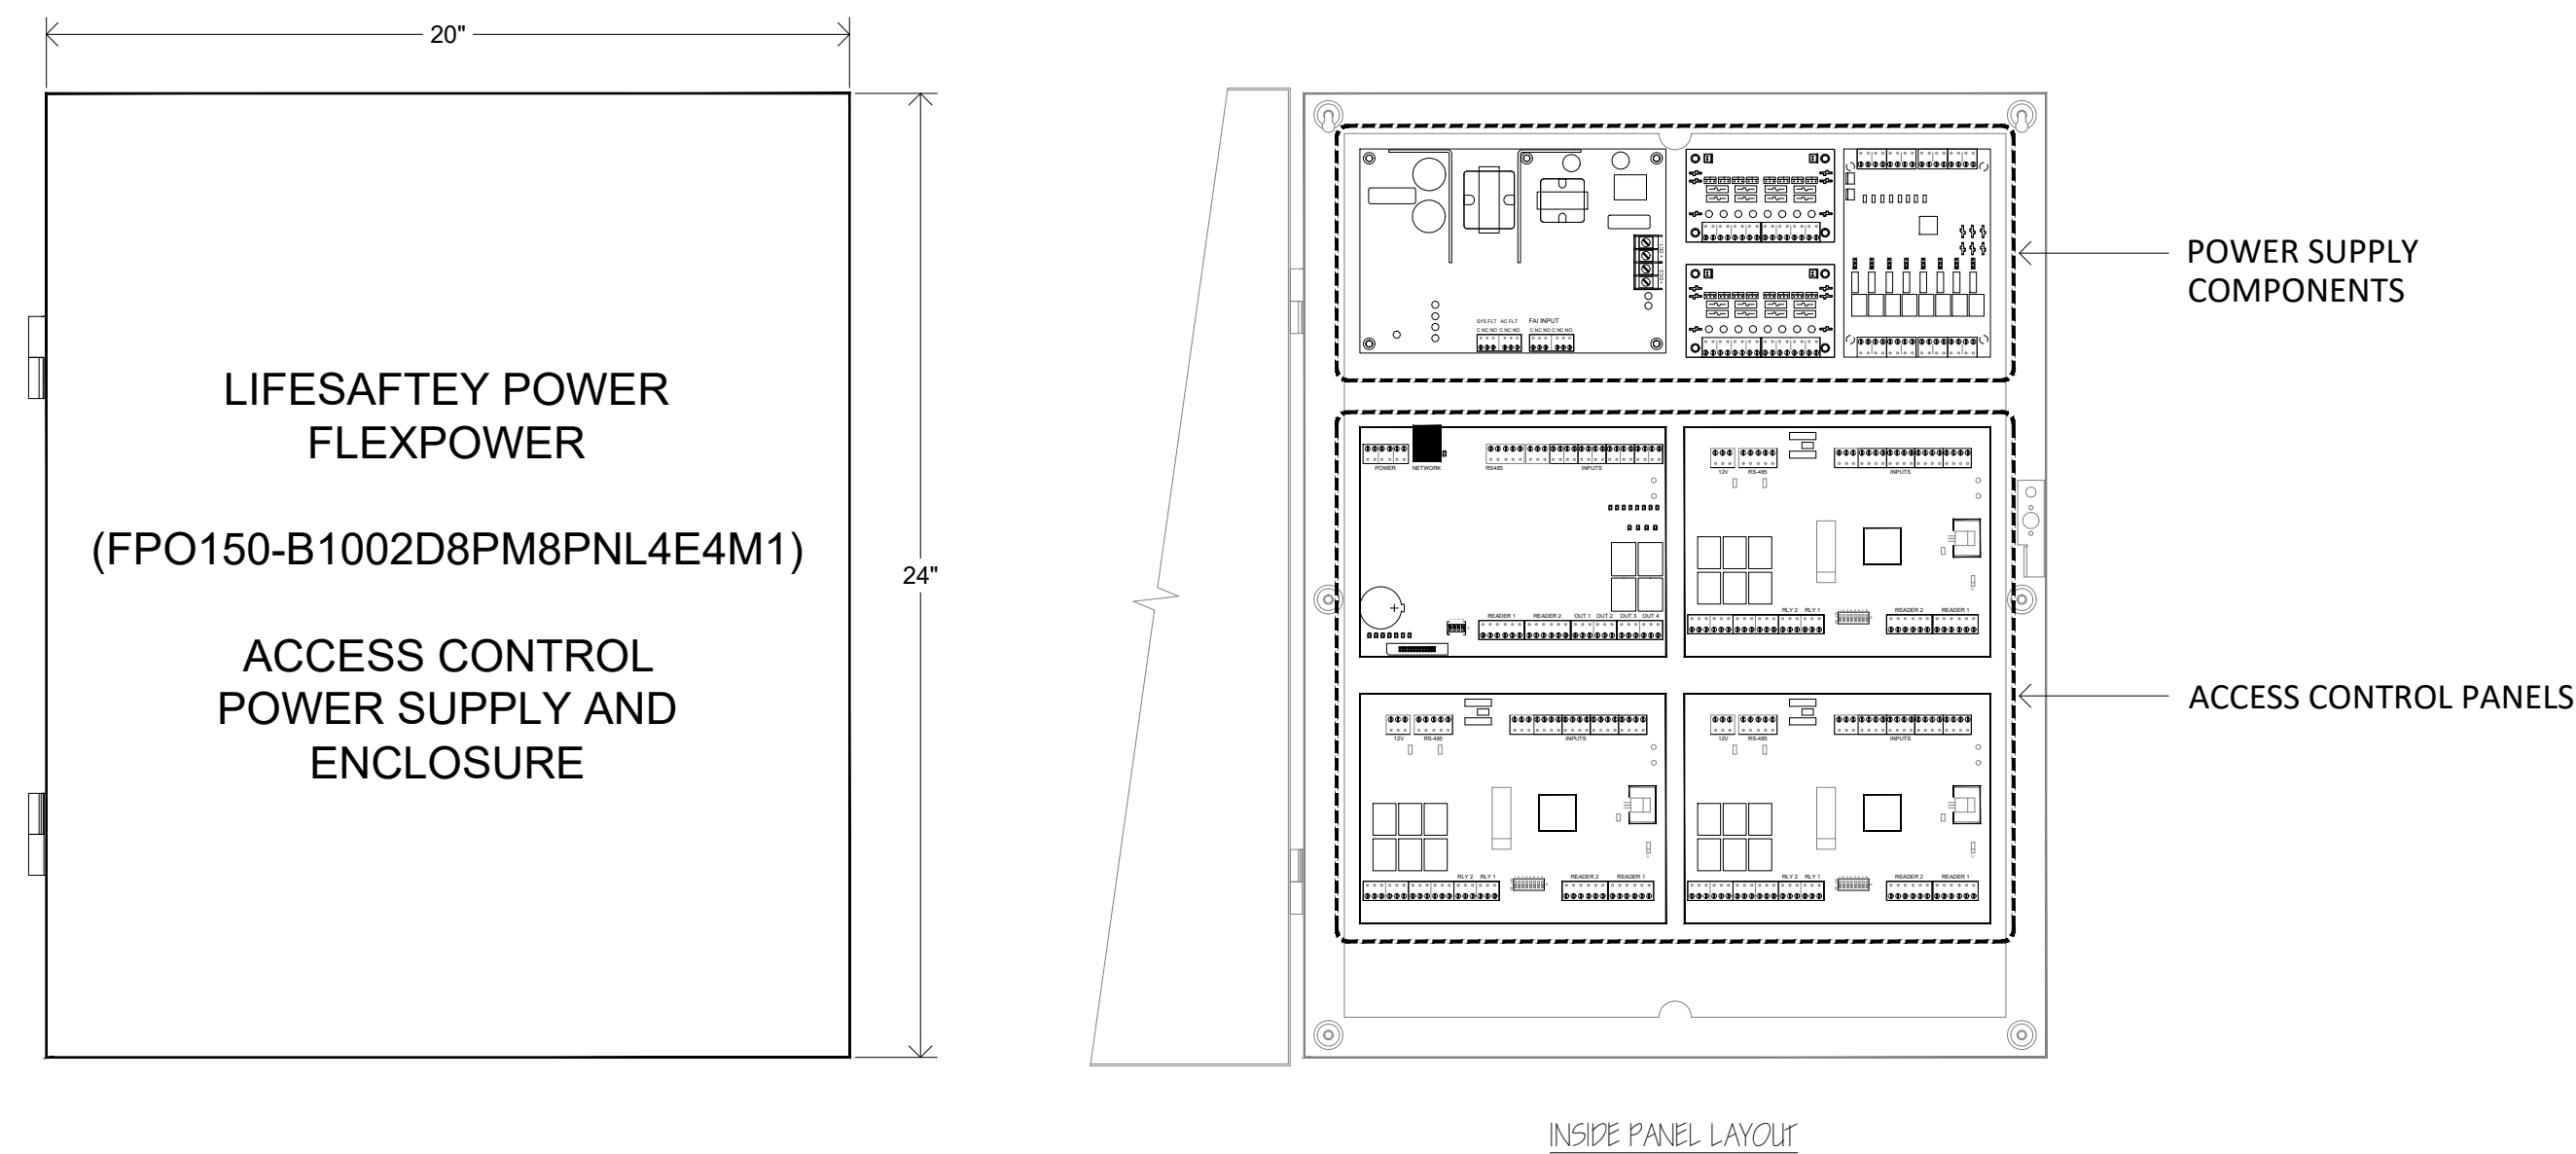

3 ACCESS CONTROL ENCLOSURE LAYOUT
SCALE: NTS

REV DATE DESCRIPTION



SECURITY GROUP NAME
STREET ADDRESS
CITY, STATE & ZIP

ACCESS CONTROL \ IP VIDEO SYSTEMS
SAMPLE SECURITY SUBMITTAL



SAMPLE SECURITY DRAWINGS
STREET ADDRESS
CITY, STATE & ZIP

JOB NO.:
DRAWN: S. ESTES
ENG/CKD:
DATE:
SCALE: 1/8"=1'-0"
SHEET TITLE:
SECURITY HEADEND ELEVATIONS
SHEET NUMBER:

ES3.0

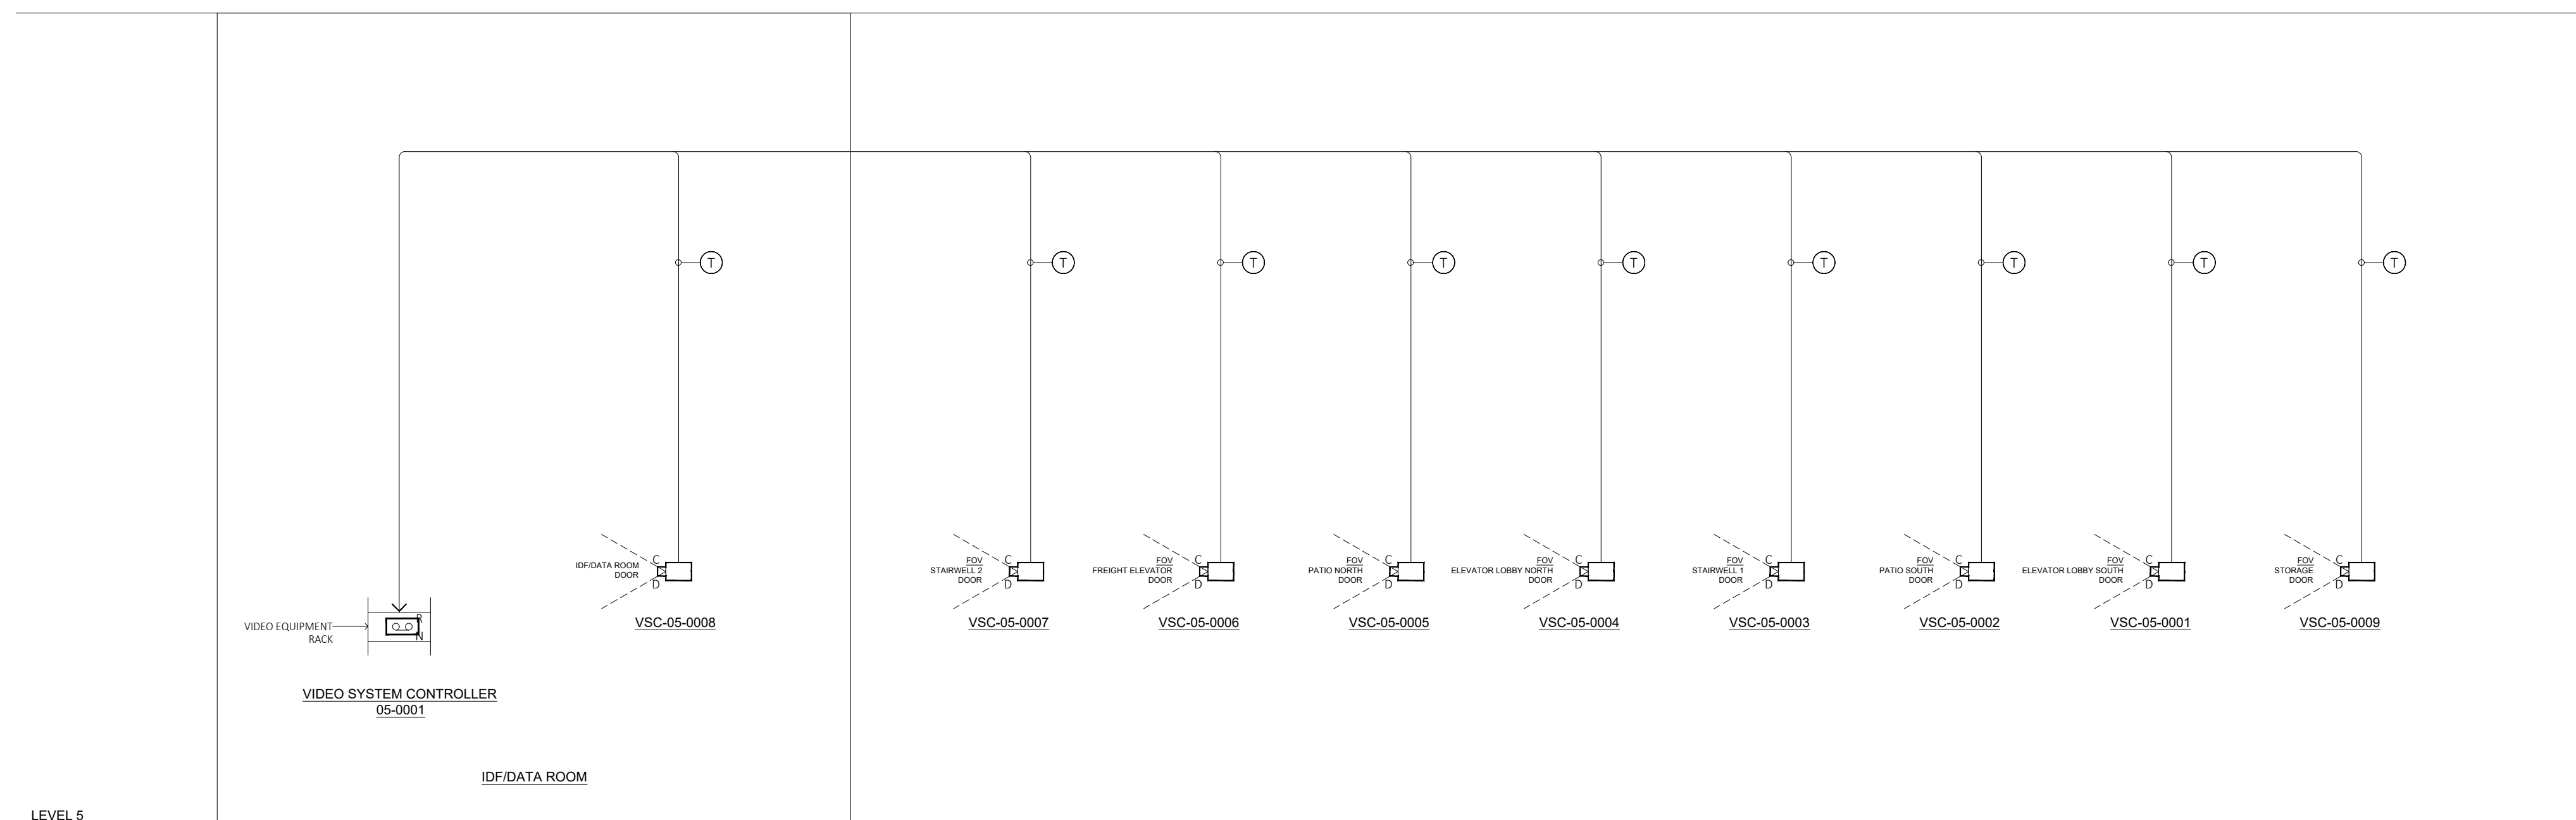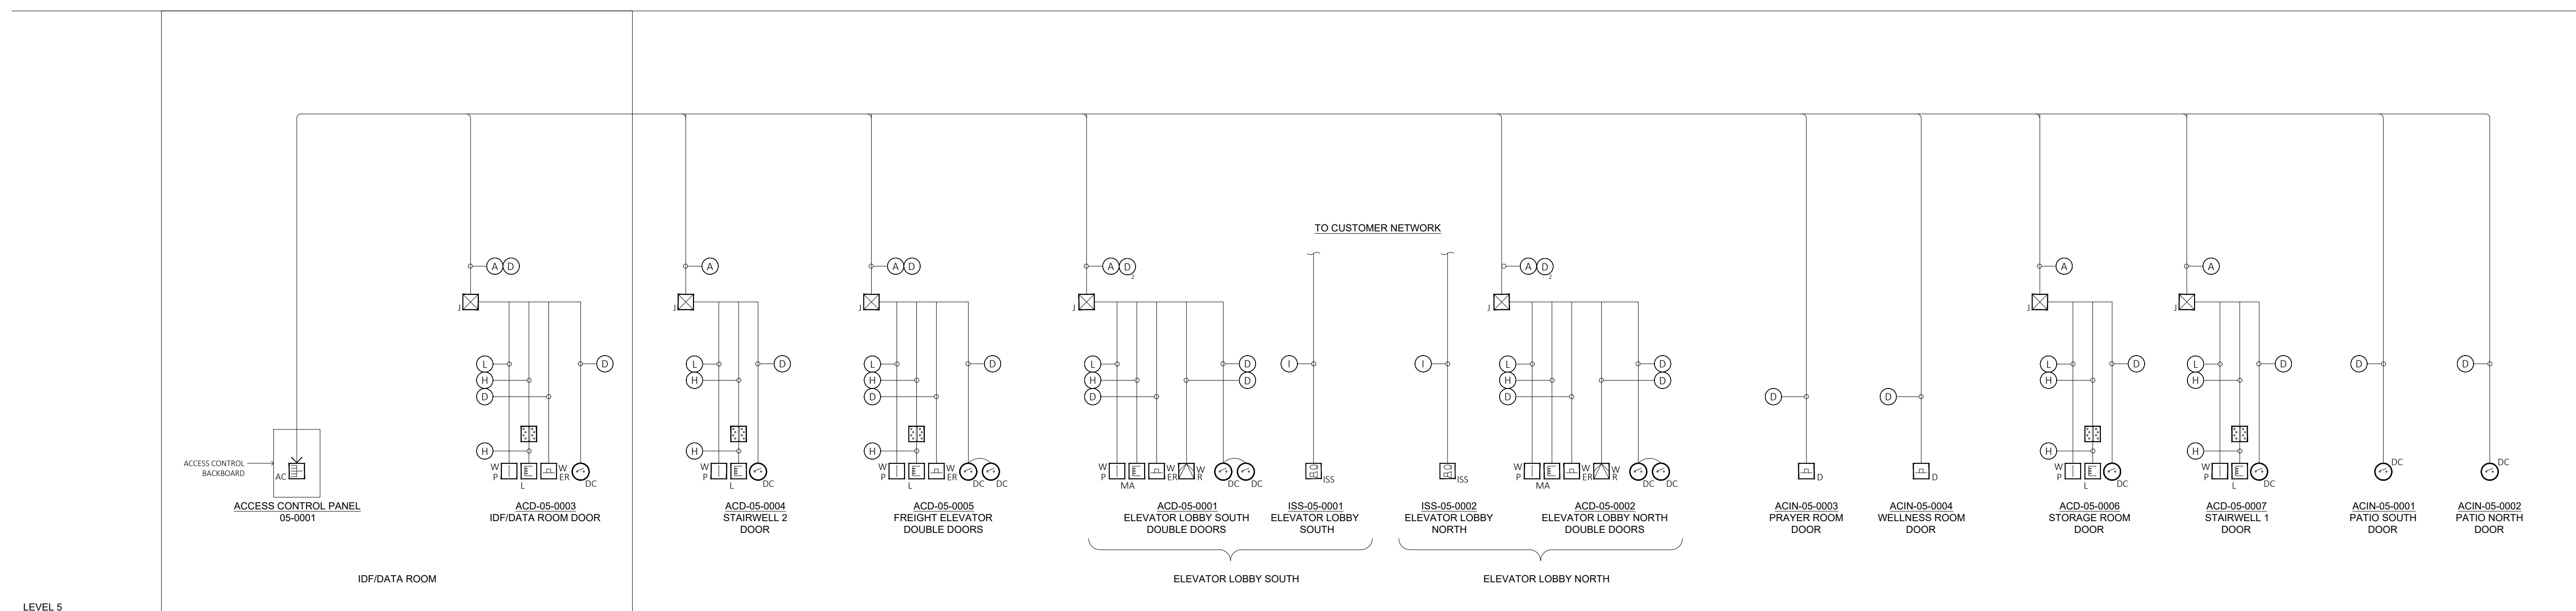

CABLE KEY	
LETTER	CABLE TYPE / DESCRIPTION
A	COMPOSITE PLENUM CABLE
B	224 STRANDED PLENUM CABLE
C	182 STRANDED PLENUM CABLE
D	186 STRANDED PLENUM CABLE
T	CAT6

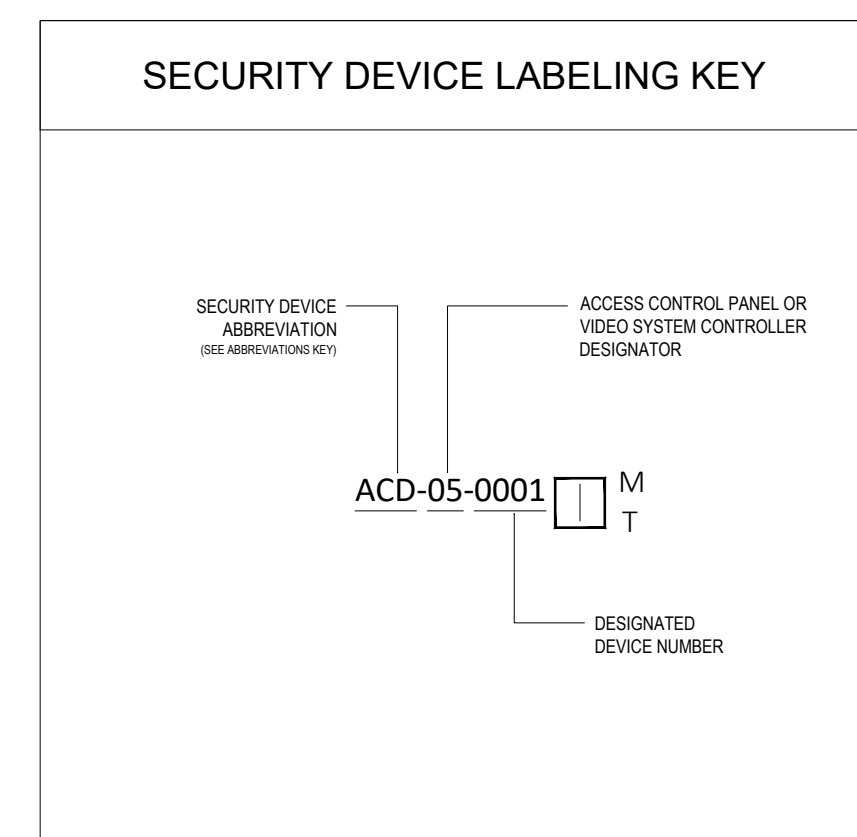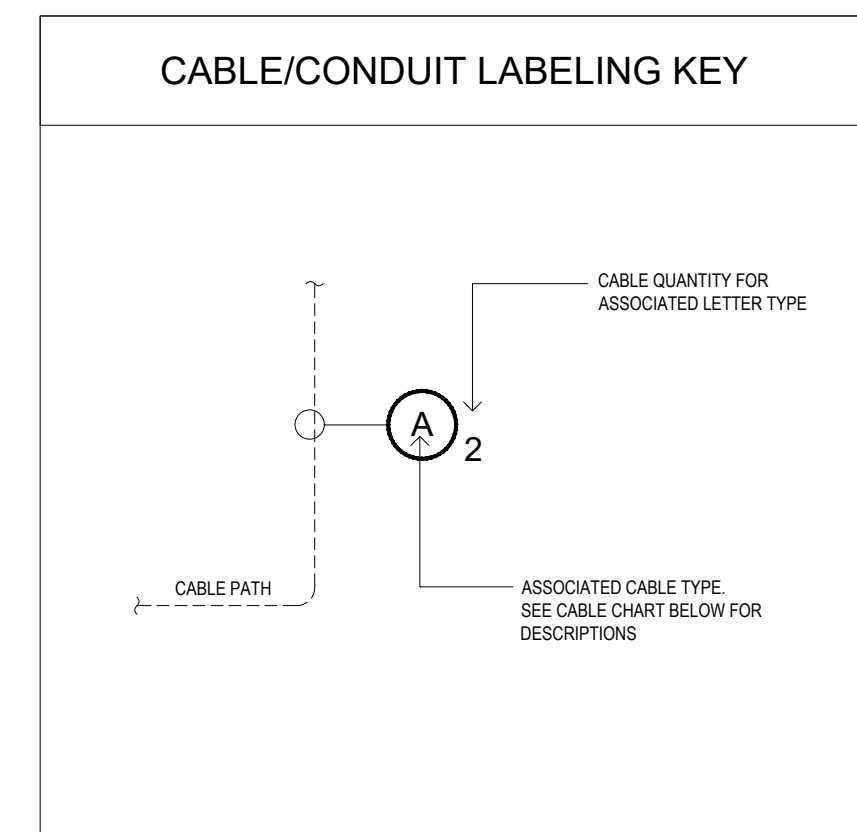

DEVICE LEGEND		
SYMBOL	DEVICE NAME	TECH TYPE OPTION
	FIXED CAMERA	D = DOME A = ANALOG IR = INFRARED LP = LICENSE PLATE
	VIDEO RECORDER	N = NETWORK A = ANALOG D = DIGITAL H = HYBRID
	CONTROL PANEL	AC = ACCESS CONTROL PANEL B = BURGLAR F = FIRE E = ELEVATOR
	INTERCOM	IS = INTERCOM SUB STATION IMS = INTERCOM MASTER STATION
	CARD READER PROXIMITY	P = PROXIMITY W = WALL MOUNT
	DOOR CONTACT	S = SURFACE MOUNT
	ACCESS BUTTON	ER = EMERGENCY DOOR RELEASE D = DURESS RDR = REMOTE DOOR RELEASE RTE = REQUEST-TO-EXIT HPP = HANDICAP PUSH PANEL EX = EXIT BUTTON
	ELECTRIFIED HINGE	
	ELECTRIFIED LOCKSET	L = LEVER LOCK S = STRIKE LOCK MA = MAGNETIC LOCK
	ELECTRIFIED LEVER LOCK WITH REX IN HANDLE	L = LEVER LOCK
	ELECTRIFIED MAGNETIC LOCK	MA = MAGNETIC LOCK
	MOTION DETECTOR - REX	R = REQUEST-TO-EXIT W = WALL MOUNT
	FIELD PANEL	AC = ACCESS CONTROL PANEL B = BURGLAR F = FIRE E = ELEVATOR G = GATE CONTROL P = ELEVATOR
	FIELD PANEL ACCESS CONTROL	AC = ACCESS CONTROL PANEL W = WALL MOUNT
	FIELD BOX	J = JUNCTION BOX

REV	DATE	DESCRIPTION
SECURITY GROUP NAME		
STREET ADDRESS		
CITY, STATE & ZIP		
ACCESS CONTROL \ IP VIDEO SYSTEMS		
SAMPLE SECURITY SUBMITTAL		
SAMPLE SECURITY DRAWINGS		
STREET ADDRESS		
CITY, STATE & ZIP		
JOB NO.:		
DRAWN: S.ESTES		
ENG/CKD:		
DATE:		
SCALE: NONE		
SHEET TITLE:		
ACCESS CONTROL & VIDEO SYSTEM RISER DIAGRAMS		
SHEET NUMBER:		
ES5.0		

